

4/6/2026 3:47:02 PM

HVAC LEGEND

SYMBOL	ITEM	SYMBOL	ITEM	SYMBOL	ITEM
	RECTANGULAR DUCTWORK, SIZES SHOWN ARE INTERNAL CLEAR DIMENSIONS (WIDTH x HEIGHT).		SMOKE DETECTOR		NEW CONNECTION POINT
	INTERNALLY LINED RECTANGULAR DUCTWORK, SIZES SHOWN ARE INTERNAL CLEAR DIMENSIONS.		FLEXIBLE PIPE CONNECTOR		DISCONNECTION POINT
	ROUND SNAPLOCK GALVANIZED STEEL DUCTWORK, EXTERNALLY INSULATED, SMACNA STATIC PRESSURE CONSTRUCTION CLASS 1/2" W.G., SEAL CLASS C. SIZE SHOWN IS SHEET METAL DIAMETER. SHALL BE USED ONLY AT RUNOUTS TO AIR OUTLETS.		PRESSURE GAGE WITH GAGE COCK		DUCTWORK TO BE DEMOLISHED
	FACTORY FABRICATED/INSULATED FLEXIBLE ROUND DUCT, SIZE SHOWN IS INSIDE DIAMETER.		COMBINATION PRESSURE AND TEMPERATURE TEST PLUG WITH EXTENDED NECK AND CAP		MOTORIZED DAMPER
	ROUND SPIRAL SEAM GALVANIZED STEEL DUCTWORK, EXTERNALLY INSULATED, SIZE SHOWN IS SHEET METAL DIAMETER. SMACNA STATIC PRESSURE CLASS 4" W.G., SEAL CLASS C.		CONDENSATE PIPING		FIRE DAMPER/COMBINATION FIRE SMOKE DAMPER WITH ACTUATORS AND ACCESS PANELS
	SQUARE THROAT ELBOW IN RECTANGULAR DUCT WITH DOUBLE WALL TURNING VANES.		ELBOW TURN UP		NUMBER ON SHEET WHERE SECTION OCCURS
	LONG RADIUS ELBOW IN RECTANGULAR DUCT.		ELBOW TURN DOWN		SHEET WHERE SECTION OCCURS
	FLEXIBLE DUCT CONNECTION		CONNECTION, TOP		LETTER INDICATES SECTION
	TRANSITION		CONNECTION, BOTTOM		SHEET WHERE SECTION IS DRAWN
	RECTANGULAR TO ROUND DUCT TRANSITION.		MOTOR STARTER		SHEET WHERE SECTION OCCURS
	RECTANGULAR BRANCH DUCT TAKE OFF FROM RECTANGULAR DUCT MAIN WITH 45° COLLAR.		SPACE HUMIDITY SENSOR, MOUNT 48" A.F.F.; PROVIDE LOCKING THERMOSTAT COVER		HORIZONTAL FIRE DAMPER IN FLOOR/CEILING
	RECTANGULAR DUCTWORK TURNING 90° UP.		SPACE THERMOSTAT SERVING UNIT #, MOUNT 48" A.F.F.; PROVIDE LOCKING THERMOSTAT COVER		
	RECTANGULAR DUCTWORK TURNING 90° DOWN.		MANUAL VOLUME DAMPER, PROVIDE WITH LOCKING QUADRANT		
	CEILING DIFFUSER WITH 24"x24" FACE EQUAL TO "TITUS OMNI". PROVIDE SURFACE MOUNT STYLE FOR GYPSUM BOARD CEILING AND LAY-IN TYPE AT T-BAR CEILING GRID. ROUND NECK SIZE AND AIRFLOW AS INDICATED. 4-WAY DIRECTION OF THROW. PROVIDE WITH OPPOSED BLADE VOLUME CONTROL. DAMPER BACK FACE OF DIFFUSER SHALL HAVE INSULATION BLANKET.		TRANSITION POINT IN CHWS/R OR HWS/R PIPING		
			DOOR UNDERCUT		
			ROUND BRANCH DUCT TAKEOFF FROM RECTANGULAR DUCT MAIN. BRANCH DUCT SHALL BE FLEXIBLE ROUND DUCT OR ROUND SNAPLOCK DUCT AS INDICATED. ROUND DUCT TAP IN SHALL BE MADE WITH SPIN-IN COLLAR WITH MANUAL VOLUME DAMPER.		

ROOM SETPOINT SCHEDULE

SPACE	COOLING SETPOINT	HEATING SETPOINT	HUMIDITY SETPOINT	NIGHT SETBACK COOLING SETPOINT	NIGHT SETBACK HEATING SETPOINT	NIGHT SETBACK HUMIDITY SETPOINT	DEADBAND
INSIDE - GENERAL	74 DEG F	68 DEG F	50% RH	85 DEG F	55 DEG F	65% RH	3 DEG F

CODE REFERENCES

I.

ALL WORK SHALL COMPLY WITH ALL LOCAL BUILDING CODES, LAWS, REGULATIONS, ORDINANCES, AND CODES AS FOLLOWS:

1.1

ACCESSIBILITY: FLORIDA BUILDING CODE - 2023 8TH EDITION

1.2

ENERGY CONSERVATION: FLORIDA BUILDING CODE - 2023 8TH EDITION

1.3

BUILDING: FLORIDA BUILDING CODE - 2023 8TH EDITION

1.4

EXISTING BUILDING: FLORIDA BUILDING CODE - 2023 8TH EDITION

1.5

FUEL GAS: FLORIDA BUILDING CODE - 2023 8TH EDITION

1.6

MECHANICAL: FLORIDA BUILDING CODE - 2023 8TH EDITION

1.7

PLUMBING: FLORIDA BUILDING CODE - 2023 8TH EDITION

1.8

NATIONAL ELECTRICAL CODE - 2014 EDITION

1.9

NATIONAL FIRE PROTECTION ASSOCIATION (NFPA) 101, 2015 LIFE SAFETY CODE FOR FLORIDA

1.10

APPLICABLE CODE SECTIONS AS REQUIRED BY FLORIDA ADMINISTRATIVE CODE 69A-3.012

1.11

AMERICANS WITH DISABILITY ACT 2010 (ADA 2010)

ABBREVIATIONS

ACD - AUTOMATIC CONTROL DAMPER	HP - HORSEPOWER
ACH - AIR CHANGE PER HOUR	HW - HOT WATER
ACT - ACOUSTICAL CEILING TILE	IAW - IN ACCORDANCE WITH
AHU - AIR HANDLING UNIT	IPLV - INTEGRATED PART LOAD VALUE
AMB - AMBIENT	LSL - LINEAR SLOT DIFFUSER
BV - BRICK VENT	MAX - MAXIMUM
CD - CEILING DIFFUSER	MBTU - THOUSAND BRITISH THERMAL UNIT
CFH - CUBIC FEET PER HOUR	MH - MANHOLE
CFM - CUBIC FEET PER MINUTE	MIN - MINIMUM
CW - COLD WATER	MVD - MANUAL VOLUME DAMPER
DB - DRY BULB	NIC - NOT IN CONTRACT
DDC - DIRECT DIGITAL CONTROL	OA - OUTSIDE AIR
DG - DOOR GRILLE	OAL - OUTSIDE AIR LOUVER
DPS - DIFFERENTIAL PRESSURE SENSOR	RA - RETURN AIR
EA - EXHAUST AIR	RPM - REVOLUTIONS PER MINUTE
EAG - EXHAUST AIR GRILLE	SA - SUPPLY AIR
EAL - EXHAUST AIR LOUVER	SPT - STATIC PRESSURE TRANSMITTER
EF - EXHAUST FAN	SWR - SIDE WALL REGISTER
ET - EXPANSION TANK	SWS - SIDE WALL SUPPLY GRILLE
EX - EXISTING	SQ FT - SQUARE FEET
FD - FIRE DAMPER	T' STAT - THERMOSTAT
FSD - COMBINATION FIRE SMOKE DAMPER	TG - TRANSFER GRILLE
FLR - FLOOR	TS - TEMPERATURE SENSOR
FO - FLAT OVAL	TYP - TYPICAL
FT - FEET	VAV - VARIABLE AIR VOLUME
GPM - GALLONS PER MINUTE	VFD - VARIABLE FREQUENCY DRIVE
HOA - HAND-OFF-AUTOMATIC	WB - WET BULB
HGR - HOT GAS REHEAT	SS - SANITARY SEWER

HVAC NOTES

1.

T'STATS INDICATED ADJACENT TO DOORWAYS SHALL BE LOCATED WITHIN 18" OF JAMB. AT LOCATIONS WITH LIGHT SWITCHES, LOCATE T'STAT SUCH THAT LIGHT SWITCH IS BETWEEN T'STAT AND JAMB. T'STATS SHALL BE LOCATED 48" AFF. VERIFY T'STAT LOCATIONS WITH SYSTEMS FURNITURE LAYOUT PRIOR TO INSTALLING ANY T'STAT.

2.

LOUVER DIMENSIONS INDICATED DOES NOT INCLUDE FRAME OR FLANGES. APPROXIMATE ROUGH OPENING IN WALL ASSEMBLY IS INDICATED ON ARCHITECTURAL.

3.

ALL CONDENSATE PIPING SHALL BE INSULATED WITH CLOSED CELL INSULATION. PROVIDE ALUMINUM OR PVC JACKETING FOR ALL EXTERIOR CONDENSATE PIPING.

TYPICAL DUCTWORK & INSULATION NOTES

1.

ALL ROUND FLEXIBLE DUCT SHALL BE FACTORY PREINSULATED WITH THERMOFLEX OR EQUAL. MAXIMUM LENGTH OF ANY FLEXIBLE DUCT RUNOUT SHALL BE 6'-0". WHERE LENGTH REQUIRED EXCEEDS 6'-0", INSTALL EXTERNALLY INSULATED ROUND SNAPLOCK DUCT FOR BALANCE OF DISTANCE TO SPIN-IN TAP AT MAIN DUCT TRUNK.

2.

SEAL ALL DUCT PENETRATIONS OF WALLS AIRTIGHT, REGARDLESS OF WHETHER WALLS ARE FIRE RATED OR NOT.

3.

ALL SUPPLY AIR DUCTWORK (EXCEPT TAKEOFFS TO SUPPLY AIR DIFFUSERS) SHALL BE LOW PRESSURE RECTANGULAR, SMACNA STATIC PRESSURE CLASS 1" W.G., SEAL CLASS C, EXTERNALLY INSULATED WITH 2" THICK FIBERGLASS DUCT WRAP.

4.

ALL RETURN AIR DUCTWORK SHALL BE LOW PRESSURE RECTANGULAR, SMACNA STATIC PRESSURE CLASS 1" W.G., SEAL CLASS B. DUCT SIZES INDICATED ARE INSIDE CLEAR DIMENSIONS. PROVIDE 1" ACOUSTICAL LINER FOR FIRST 6' OF DUCT FROM EQUIPMENT. PROVIDE 2" THICK EXTERNAL FIBERGLASS WRAP.

5.

ALL OUTSIDE AIR INTAKE DUCTWORK SHALL BE LOW PRESSURE RECTANGULAR, SMACNA STATIC PRESSURE CLASS 1" W.G., SEAL CLASS B. PROVIDE 2" THICK EXTERNAL FIBERGLASS WRAP.

6.

EXHAUST AIR DUCTWORK SHALL BE LOW PRESSURE RECTANGULAR, SMACNA STATIC PRESSURE CLASS 1/2" W.G., SEAL CLASS B.

7.

ALL DUCT SIZES INDICATED ARE INSIDE CLEAR DIMENSIONS.

8.

AVOID ROUTING DUCTWORK OVER LIGHTS WHEREVER POSSIBLE. MAINTAIN MINIMUM 6" CLEARANCE BETWEEN DUCT INSULATION TO TOP OF LIGHTS.

9.

ALL EXPOSED DUCTWORK SHALL BE 1" DOUBLE WALL SPIRAL (MIN. R=4.2) PAINTED W/ DRIP PROOF PAINT.

10.

ALL GREASE DUCT SHALL BE WELDED CARBON STEEL OR STAINLESS STEEL IN ACCORDANCE W/ NFPA 96. PROVIDE ACCESS PANELS IN ACCORDANCE W/ NFPA 96 REQUIREMENTS. PROVIDE 1.5" Fyre WRAP ON ALL GREASE DUCT.

DocuSigned by:
W3 Engineering Inc.

4/6/2026 | 14:01:32 PDT

W3 Engineering Inc.
110 E. WRIGHT ST.
PENSACOLA, FL 32502
T: (850) 629-8270
F: (850) 478-4898
FL P.E. # 70595
FL AUTHORIZATION # 31078

FRICKER RESOURCE CENTER
RENOVATION PROJECT

900 N F St, Pensacola, FL 32501-2887

GMC # APEN250016

LEGEND &
GENERAL NOTES

M0.1

DS

DS

GMC

GOODWYN MILLS CAWOOD, LLC.
720 Bayfront Parkway, Suite 200
Pensacola, FL 32502
T 850.432.0706
GMCNETWORK.COM
Gerold Stevan Jamigan -
Qualifying Agent
FL Architect AR 0009953


G. GOODWYN MILLS CAWOOD, LLC.
7720 Bayfront Parkway, Suite 200
Pensacola, FL 32502
T 850.432.0706
GMCNETWORK.COM
Gerald Steven Jernigan -
Qualifying Agent
FL Architect AR 0009953

900 N F St, Pensacola, FL 32501-2887

GMC # APEN250016

[illegible]


DS

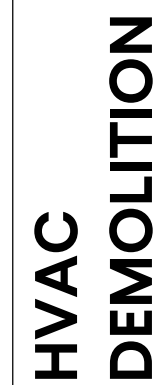

M.

THIS BUILDING AND EQUIPMENT TO BE DEMOLISHED
COMPLETELY; DEMOLISH ALL HVAC EQUIPMENT, DUCTWORK
AND PIPING

EXISTING TO REMAIN.
TEMPORARILY SUSPEND AND
REINSTALL EXISTING DIFFUSERS
INTO NEW CEILING.

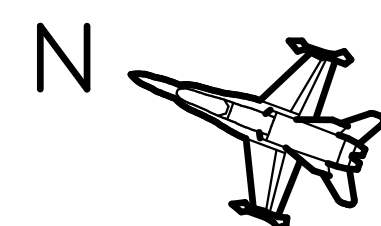

HVAC DEMOLITION PLAN

1 HVAC DEMOLITION

8' 0 8' 16'


SCALE: 1/8" = 1' - 0"

4/6/2026 | 14:01:32 PD



W3 Engineering Inc.
110 E. WRIGHT ST.
PENSACOLA, FL 32502
T: (850)629-8270
F: (888)478-4898
FL P.E. #: 70595
FL AUTHORIZATION #: 31078

Printed copies of this document are not to be considered original, the original is digitally signed

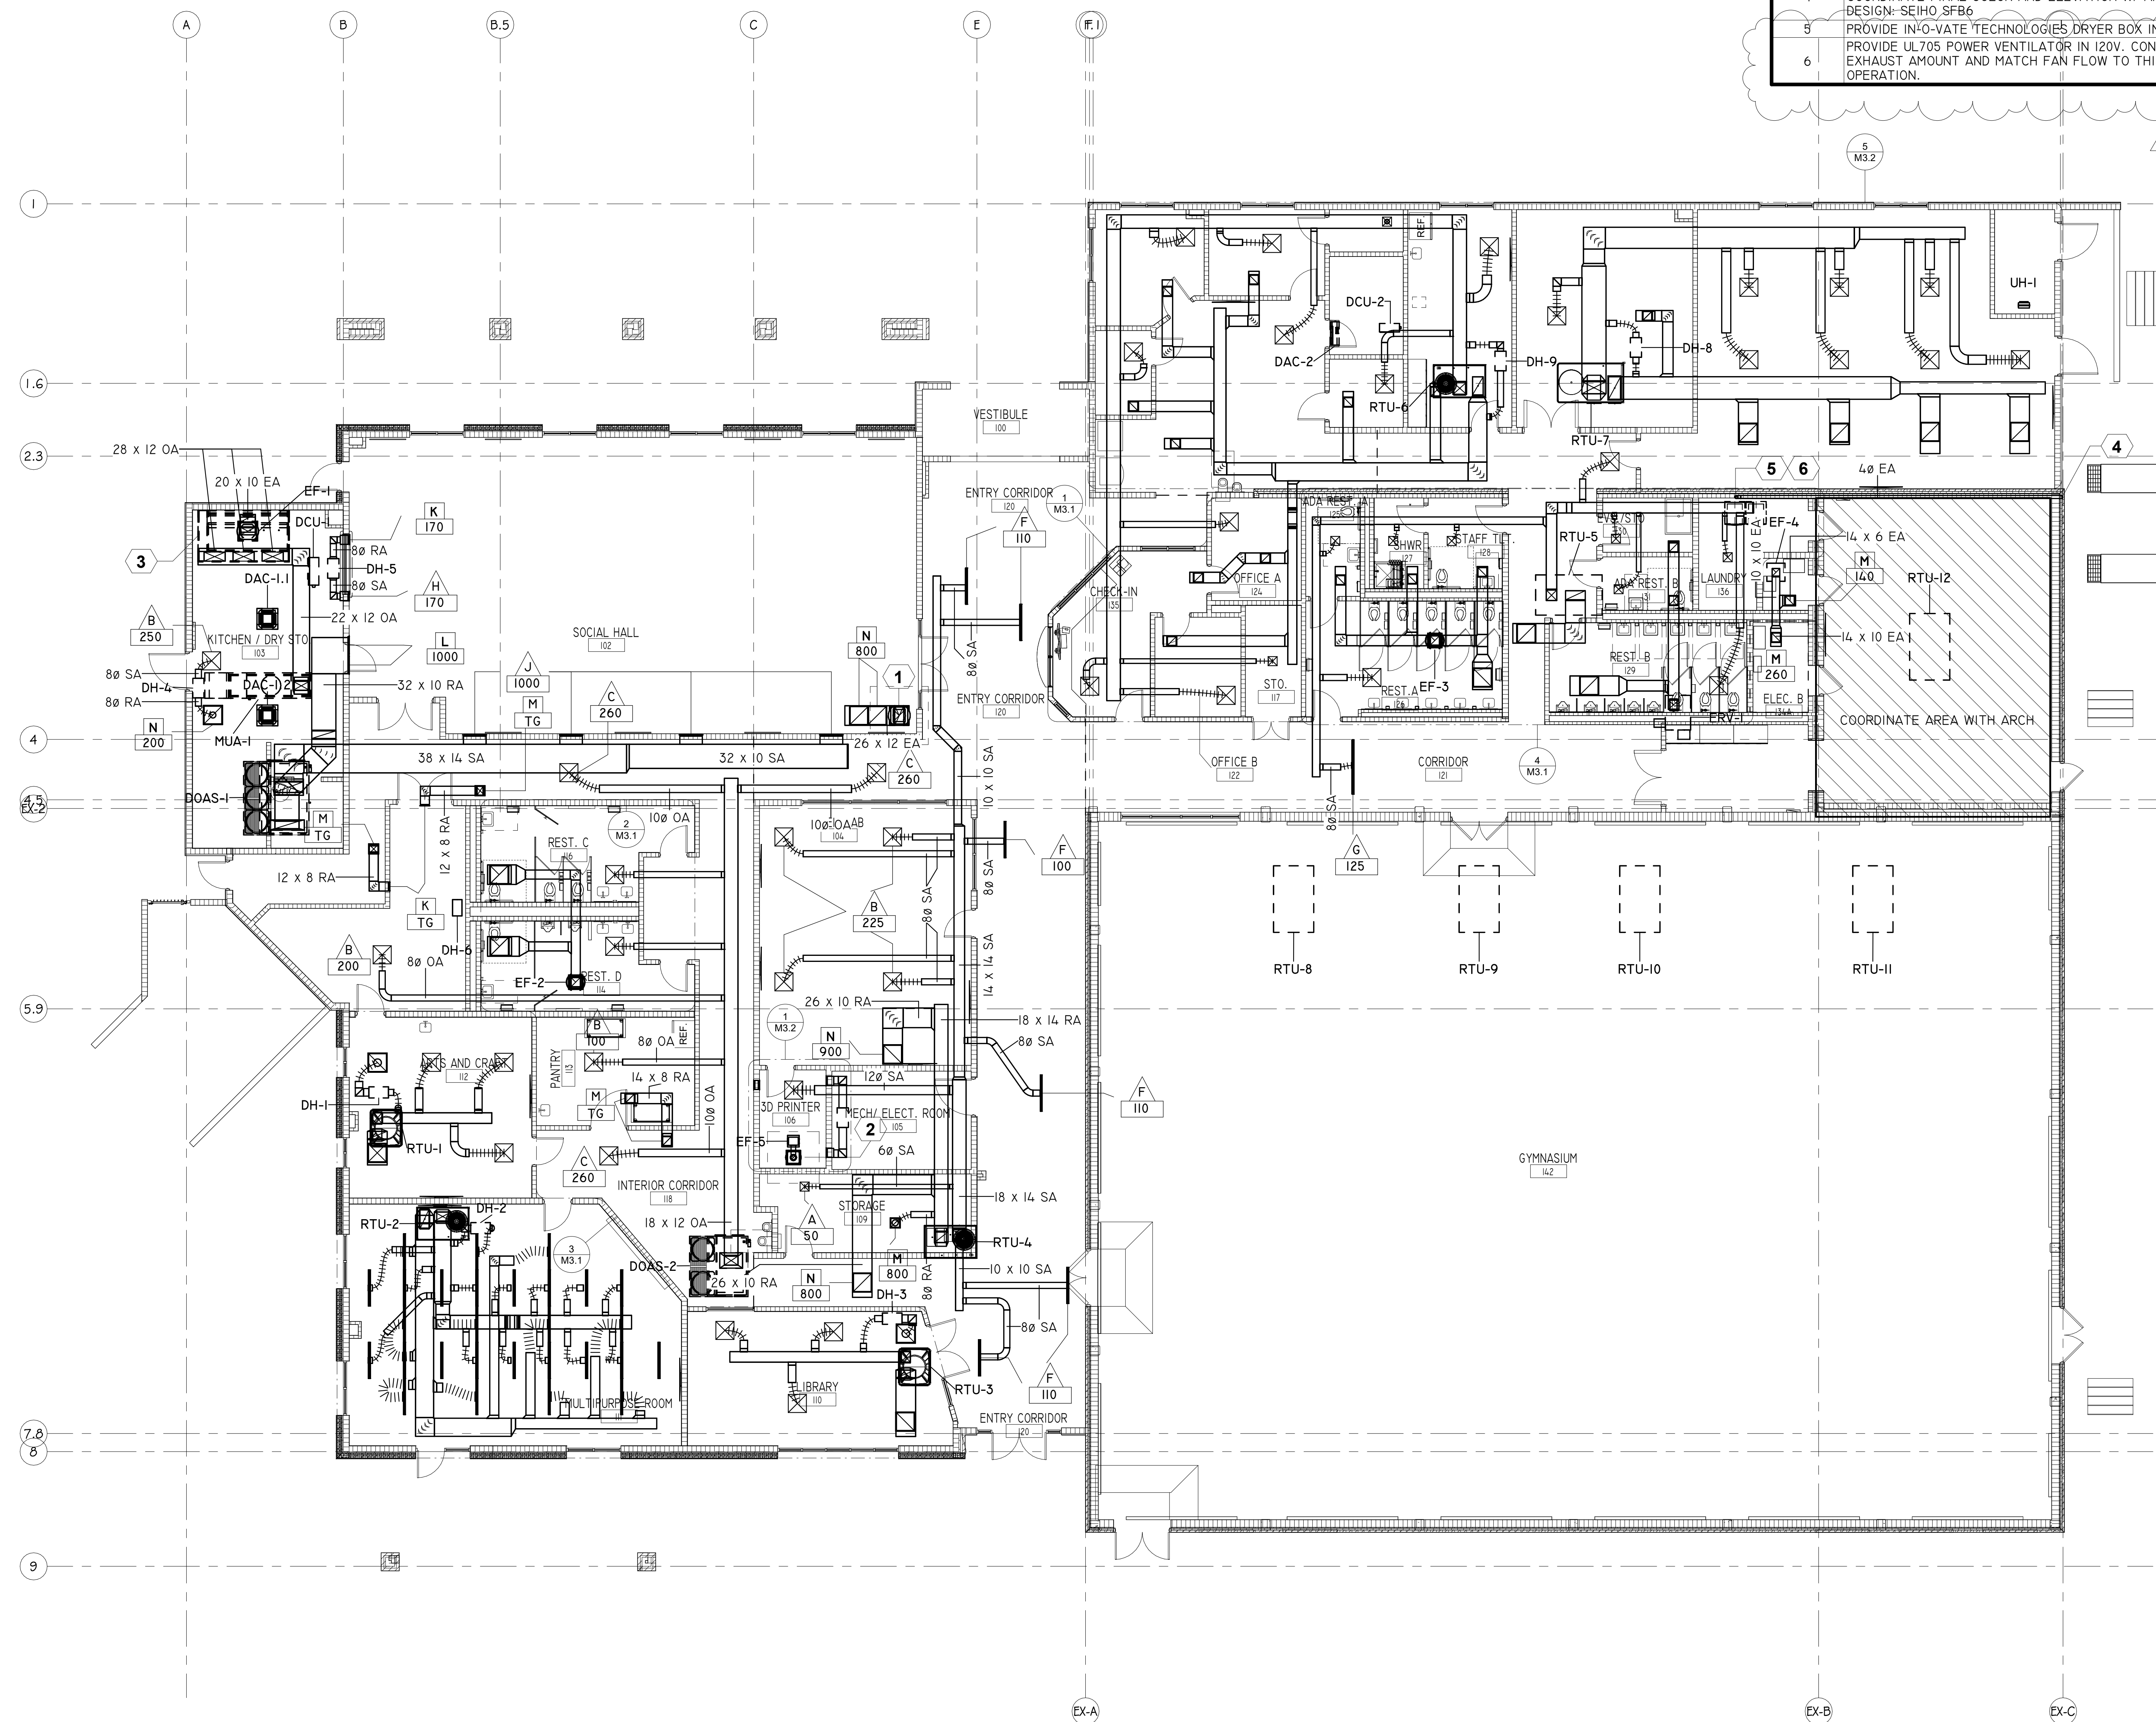

SHEET NOTES	
KEY #	KEYNOTE TEXT
1	26"x12" DUCT UP TO GRAVITY RELIEF VENTILATOR.
2	ROUTE EXHAUST DUCT UP TO LOW PROFILE ROOF CAP. BASIS OF DESIGN: GREENHECK GRSR-8
3	CONTRACTOR SHALL PROVIDE AND INSTALL KITCHEN HOOD, HOOD SUPPRESSION SYSTEM, AND ALL ACCESSORIES. ACCEPTABLE HOOD MANUFACTURERS ARE CAPTIVEAIRE AND ACCUREX.
4	PROVIDE VANDAL RESISTANT SEIHO SFX ALUMINUM DRYER VENT TERMINATION. COORDINATE FINAL COLOR AND ELEVATION W/ ARCHITECT PRIOR TO ORDERING. BASIS OF DESIGN: SEIHO SFB6
5	PROVIDE INO-VATE TECHNOLOGIES DRYER BOX IN WALL FOR DRYER CONNECTION
6	PROVIDE UL705 POWER VENTILATOR IN 120V. CONTRACTOR SHALL FIELD VERIFY DRYER EXHAUST AMOUNT AND MATCH FAN FLOW TO THIS VOLUME. INTERLOCK W/ DRYER OPERATION.



G OODWYN MILLS CAWOOD, LLC.
7720 Bayfront Parkway, Suite 200
Pensacola, FL 32502
T 850.432.0706


GMCNETWORK.COM
Gerald Steven Jernigan -
Qualifying Agent
FL Architect AR 0009953

	ISSUE	DATE
	PERMIT SET	12/08/2025
1	REV. 1 CODE COMMENT	4-6-26
	DRAWN BY:	ACL
	CHECKED BY:	IEW3

**FRICKER RESOURCE CENTER
RENOVATION PROJECT**

900 N F St, Pensacola, FL 32501-2887

GMC # APEN250016

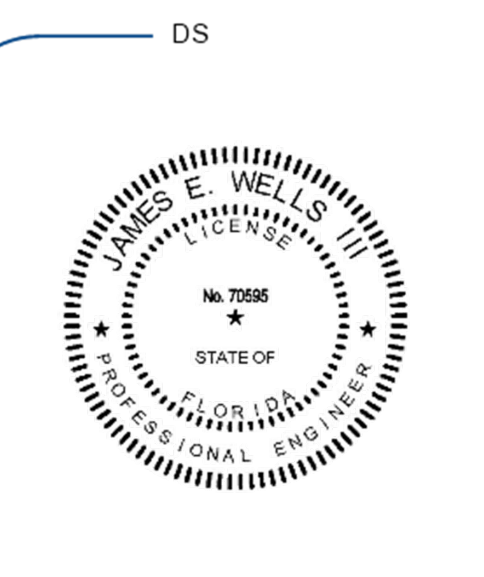

HVAC NEW WORK FLOOR PLAN

M1.2



UNIVERSITY OF WOLLONGONG
ENGINEERING


W3 Engineering Inc
110 E. WRIGHT ST.
PENSACOLA, FL 32502
T: (850)629-8270
F: (888)478-4898
FL P.E. #: 70595
FL AUTHORIZATION #: 31078

4/6/2026 | 14:01:32 PD

DocuSigned by:
10140CEE60E740
D8

Printed copies of this document are not to be considered original, the original is digitally signed

SHEET NOTES	
KEY #	KEYNOTE TEXT
1	EXISTING DUCTWORK TO REMAIN. PERFORM HVAC DUCT SYSTEM CLEANING OF ALL SUPPLY AND RETURN DUCTWORK IN ACCORDANCE WITH ACR, THE NADCA STANDARD.
2	PROVIDE SEVERE DUTY ROOF CAP. BASIS OF DESIGN: GREENHECK GRSR-8
3	PROVIDE GRAVITY RELIEF DAMPER AND VENTILATOR. BASIS OF DESIGN: GREENHECK GRSR-16
4	PROVIDE AND INSTALL PERMANENT FALL PROTECTION ATTACHMENT POINT IN ACCORDANCE WITH ANSI/ASSE Z 359.1.

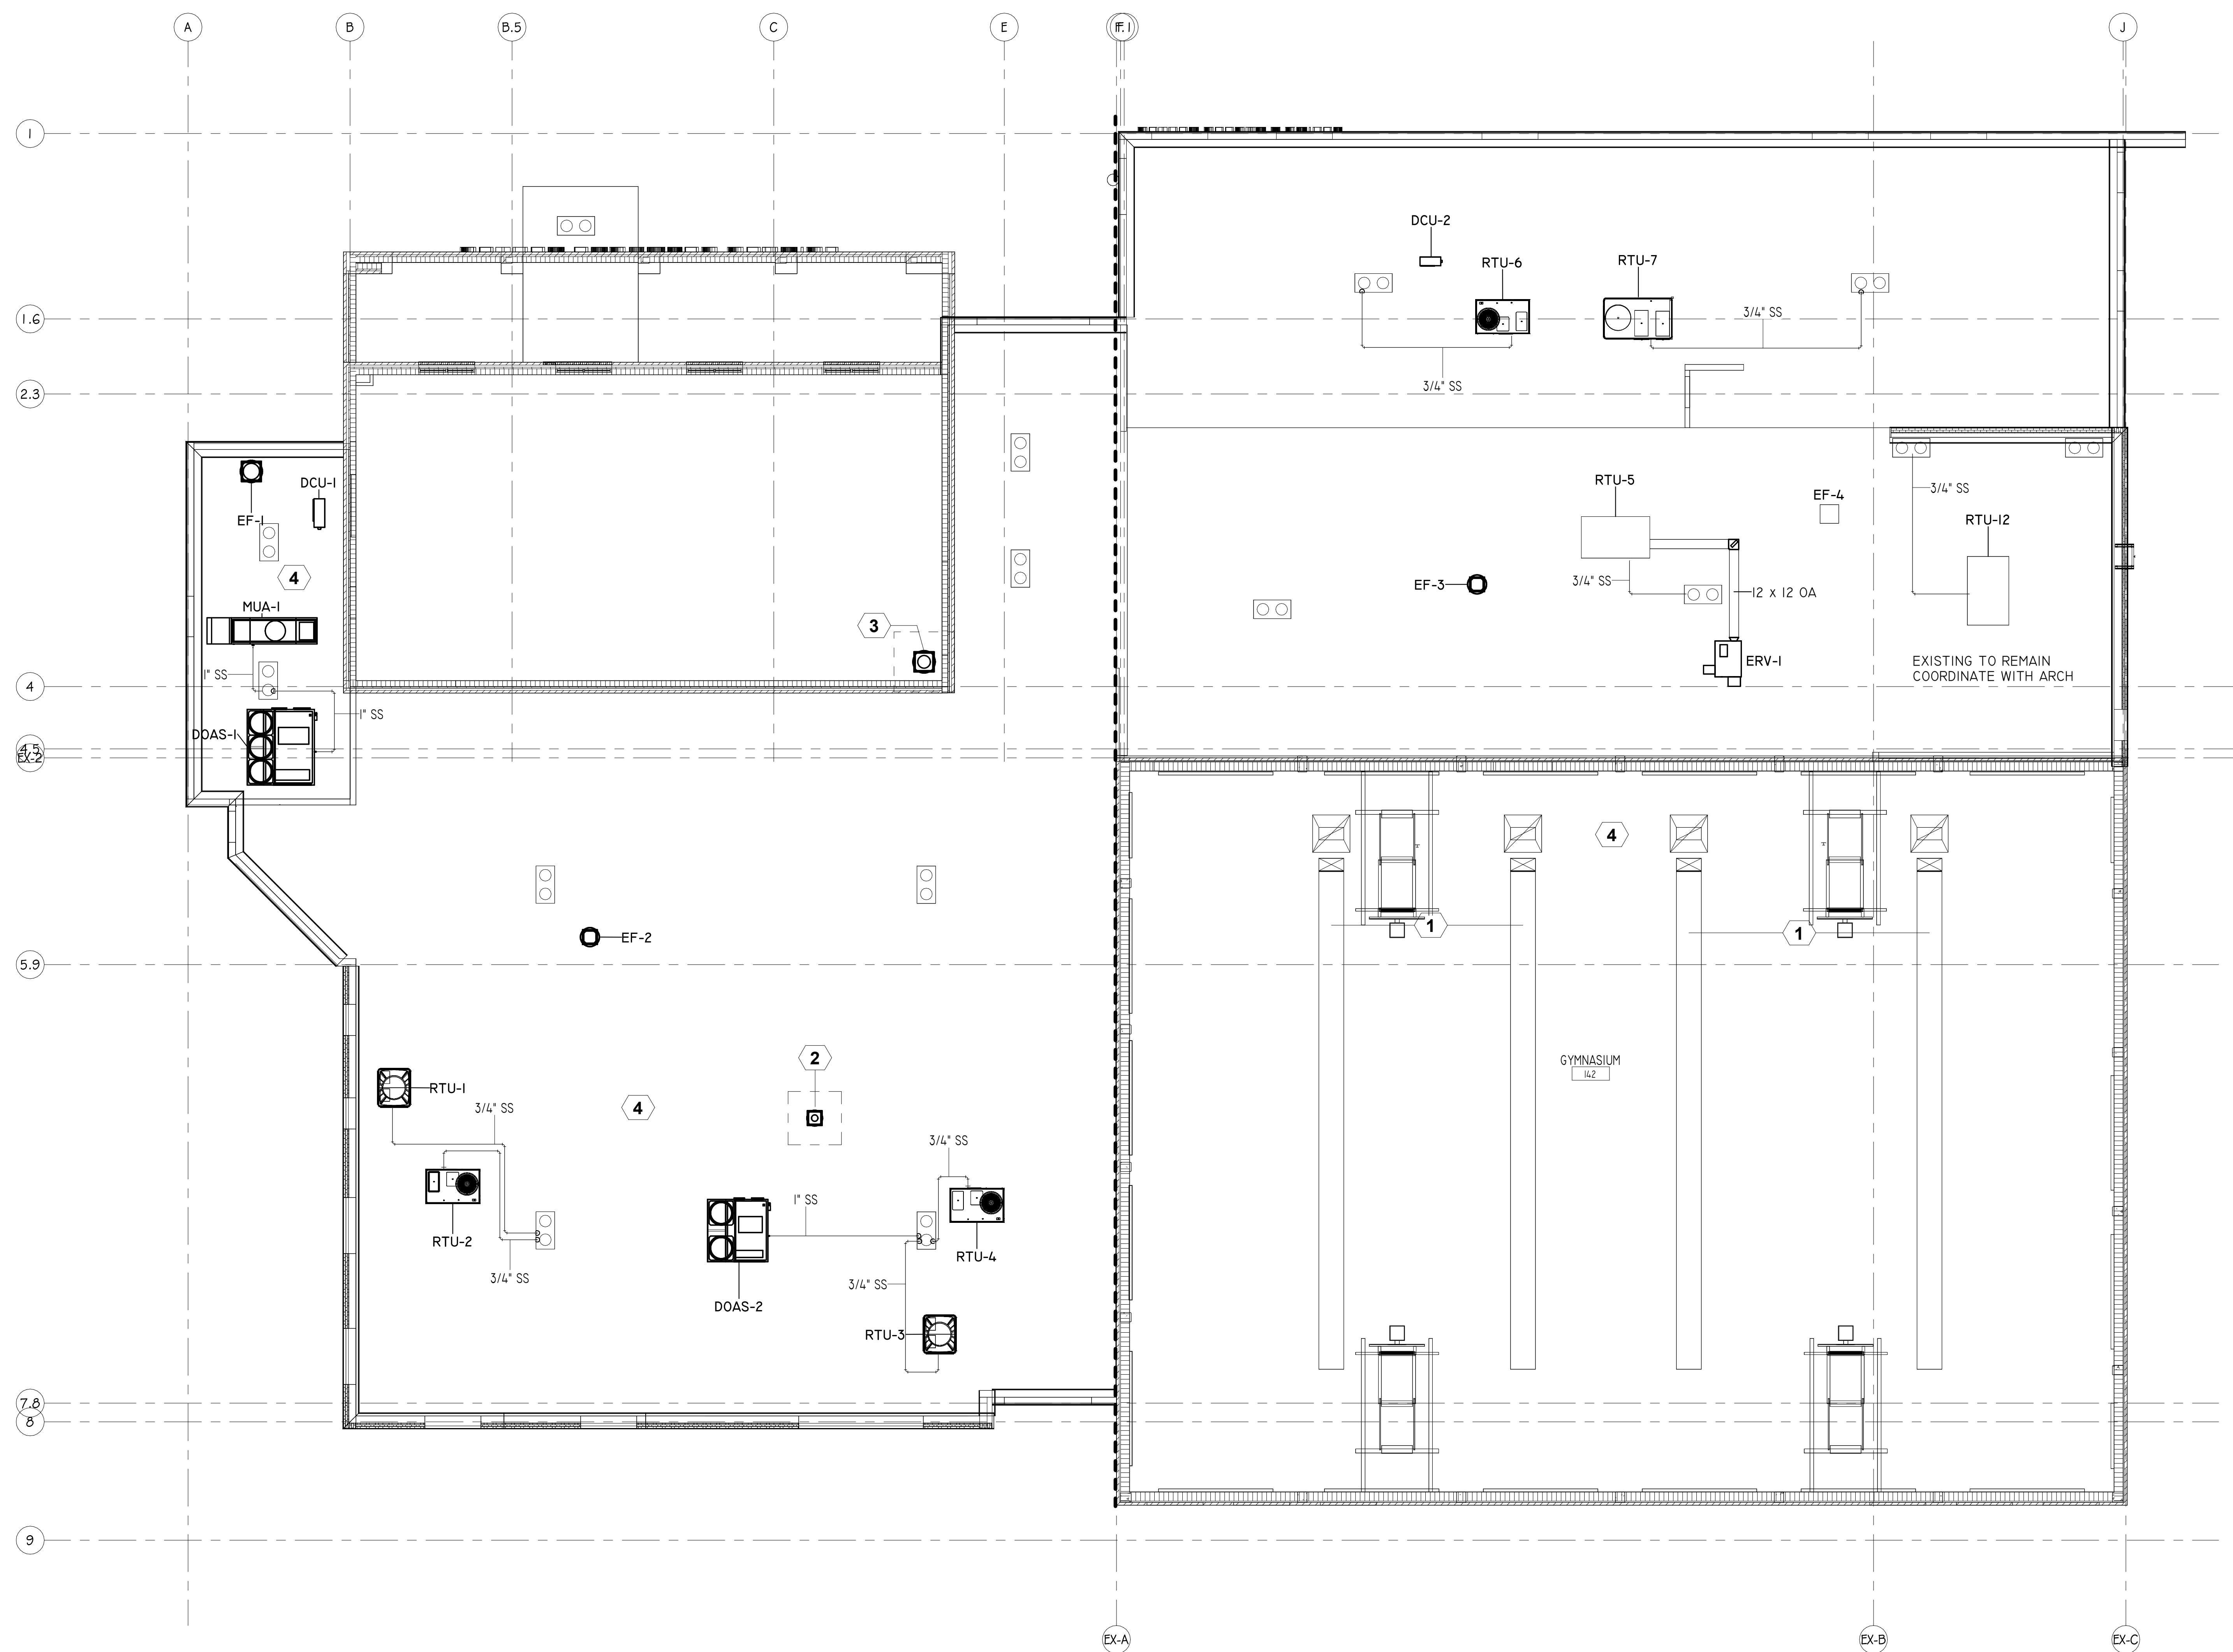

N 

② HVAC NEW WORK PLAN - LOWER ROOF

SCALE: $\frac{1}{8}" = 1' - 0"$

DocuSigned by:

 10146CEE8E745E
 D8


4/6/2026 | 14:01:32 PDT



W3 Engineering Inc.
110 E. WRIGHT ST.
PENSACOLA, FL 32502
T: (850)629-8270
F: (888)478-4898
FL P.E. #: 70595
FL AUTHORIZATION #: 31078

FL AUTHORIZATION #: 31078

**FRICKER RESOURCE CENTER
RENOVATION PROJECT**

900 N F St, Pensacola, FL 32501-2887

010002CINADV # 0710

ISSUE	DATE
-------	------

PERMIT SET	12/08/2025
------------	------------

DRAWN BY:	ACL
-----------	-----

GOODWYN MILLS CAWOOD, LLC.

720 Bayfront Parkway, Suite 200
Pensacola, FL 32502

T 850.432.0706
GMCNETWORK.COM

Gerald Steven Jemigan -

Qualifying Agent
FL Architect AR 0009953




HVAC NEW WORK LOWER ROOF PLAN




M1.3

A circular professional engineer seal for James E. Wells III. The outer ring contains the text "JAMES E. WELLS III" at the top and "PROFESSIONAL ENGINEER" at the bottom, separated by two stars. Inside this ring, the word "LICENSE" is at the top and "STATE OF FLORIDA" is at the bottom. In the center, the license number "No. 70665" is displayed above a single star.



Printed copies of this document are not to be considered original, the original is digitally signed

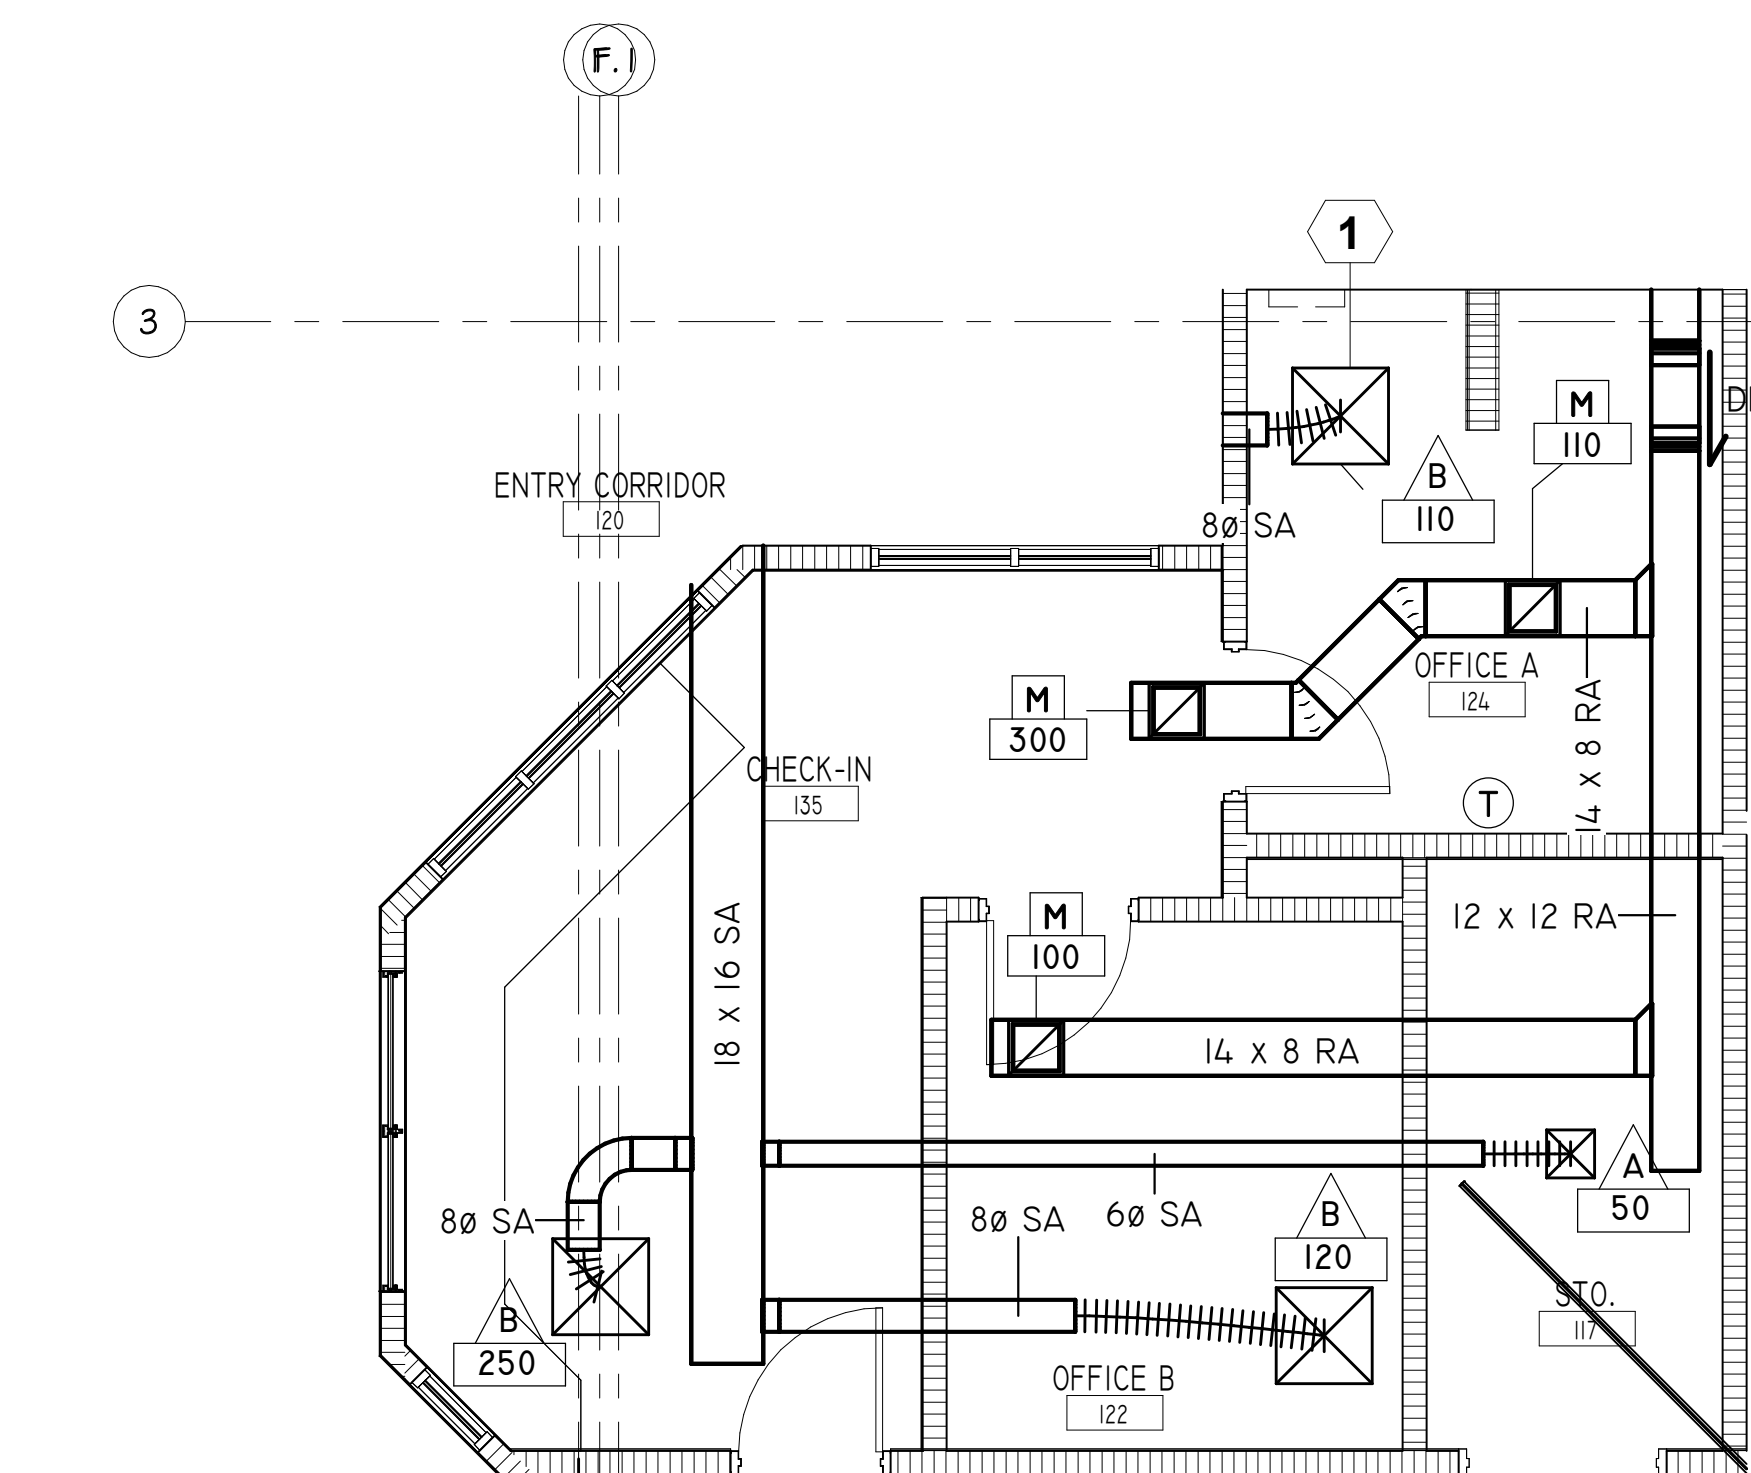




HVAC - ENLARGED CHECK-IN

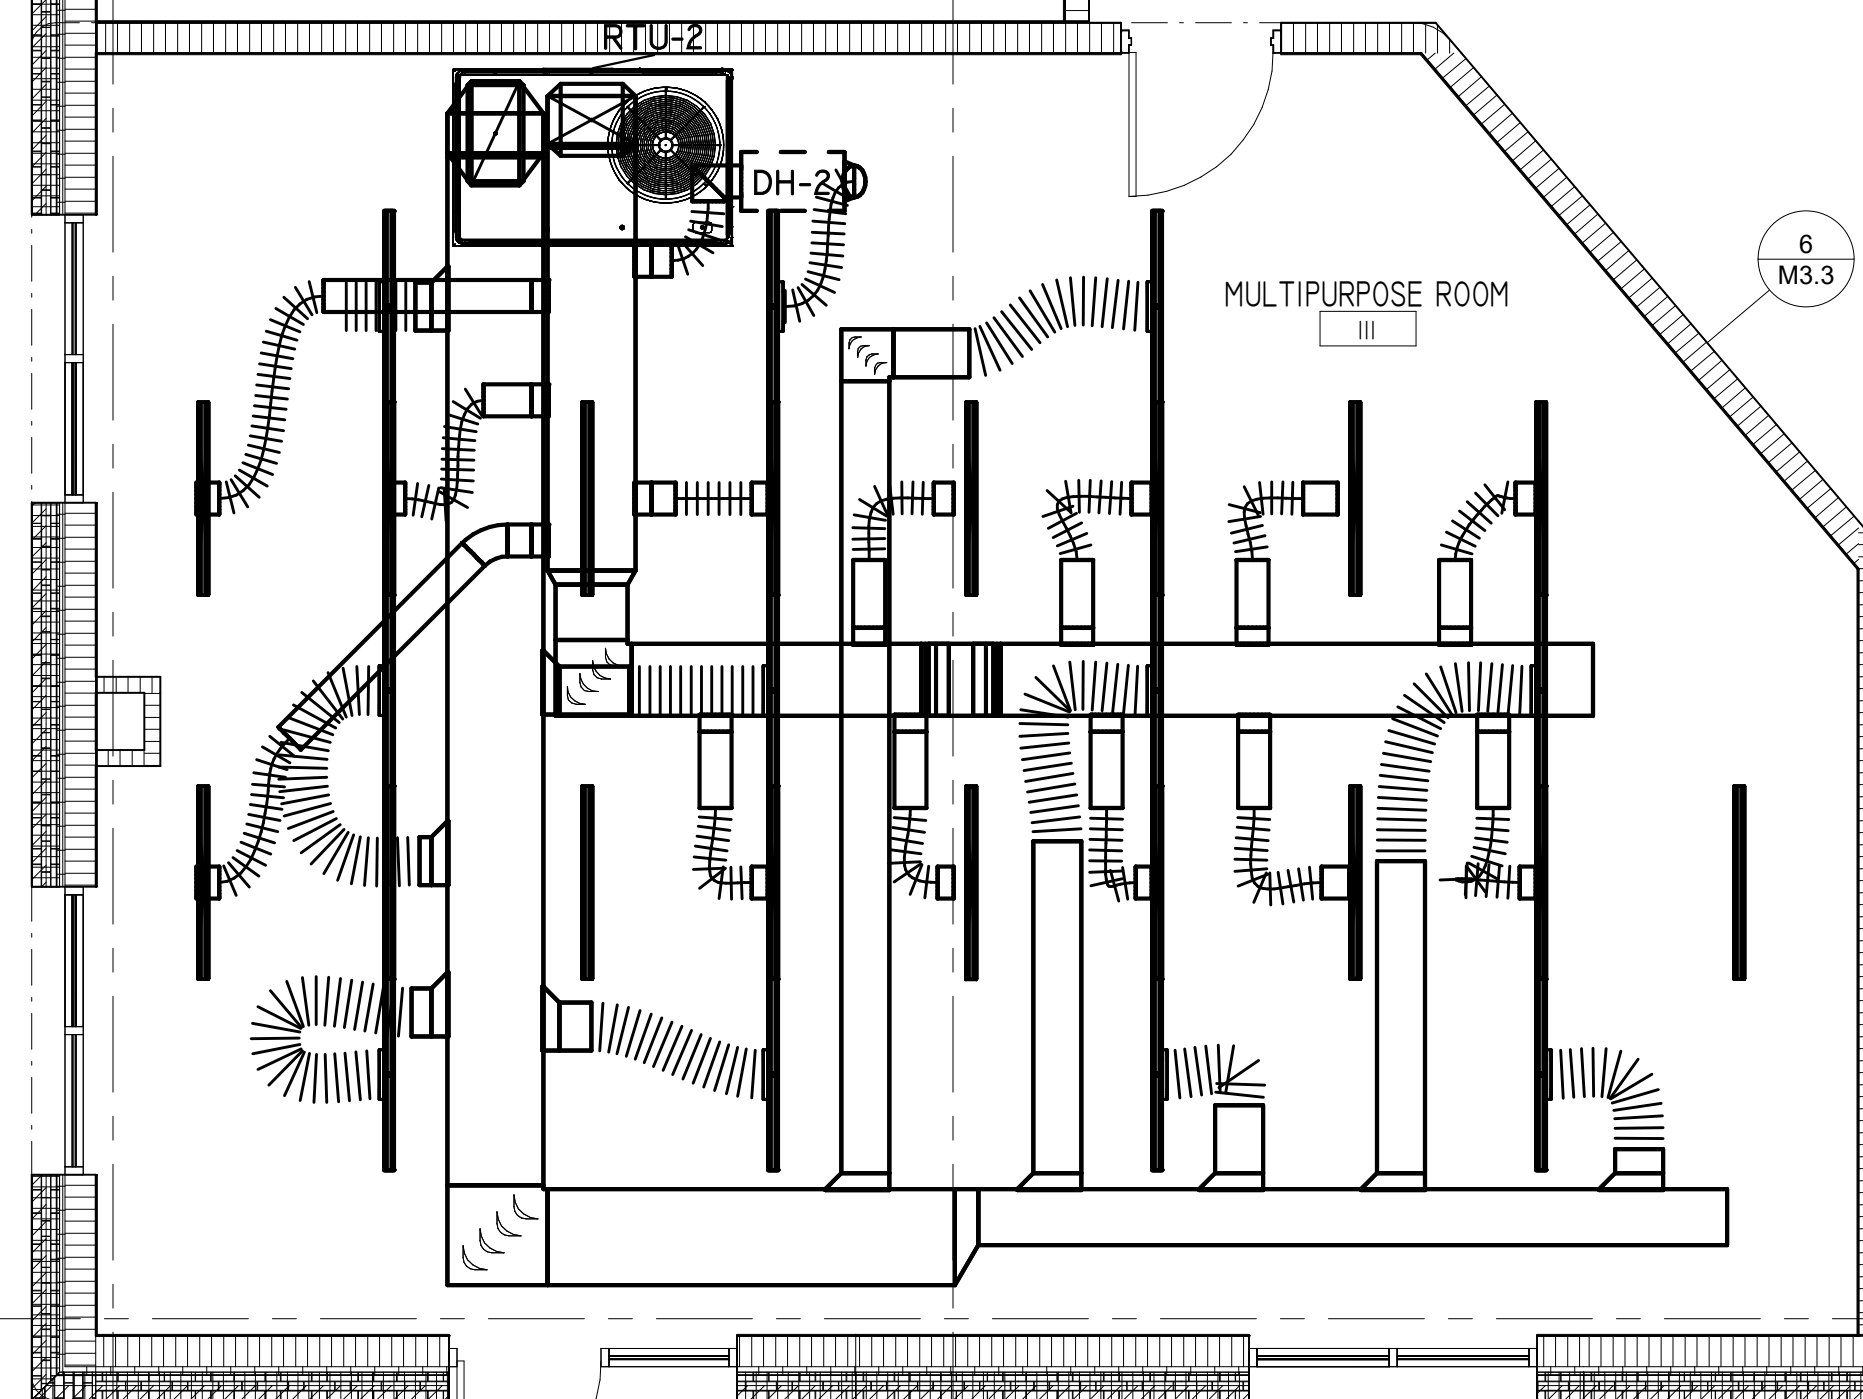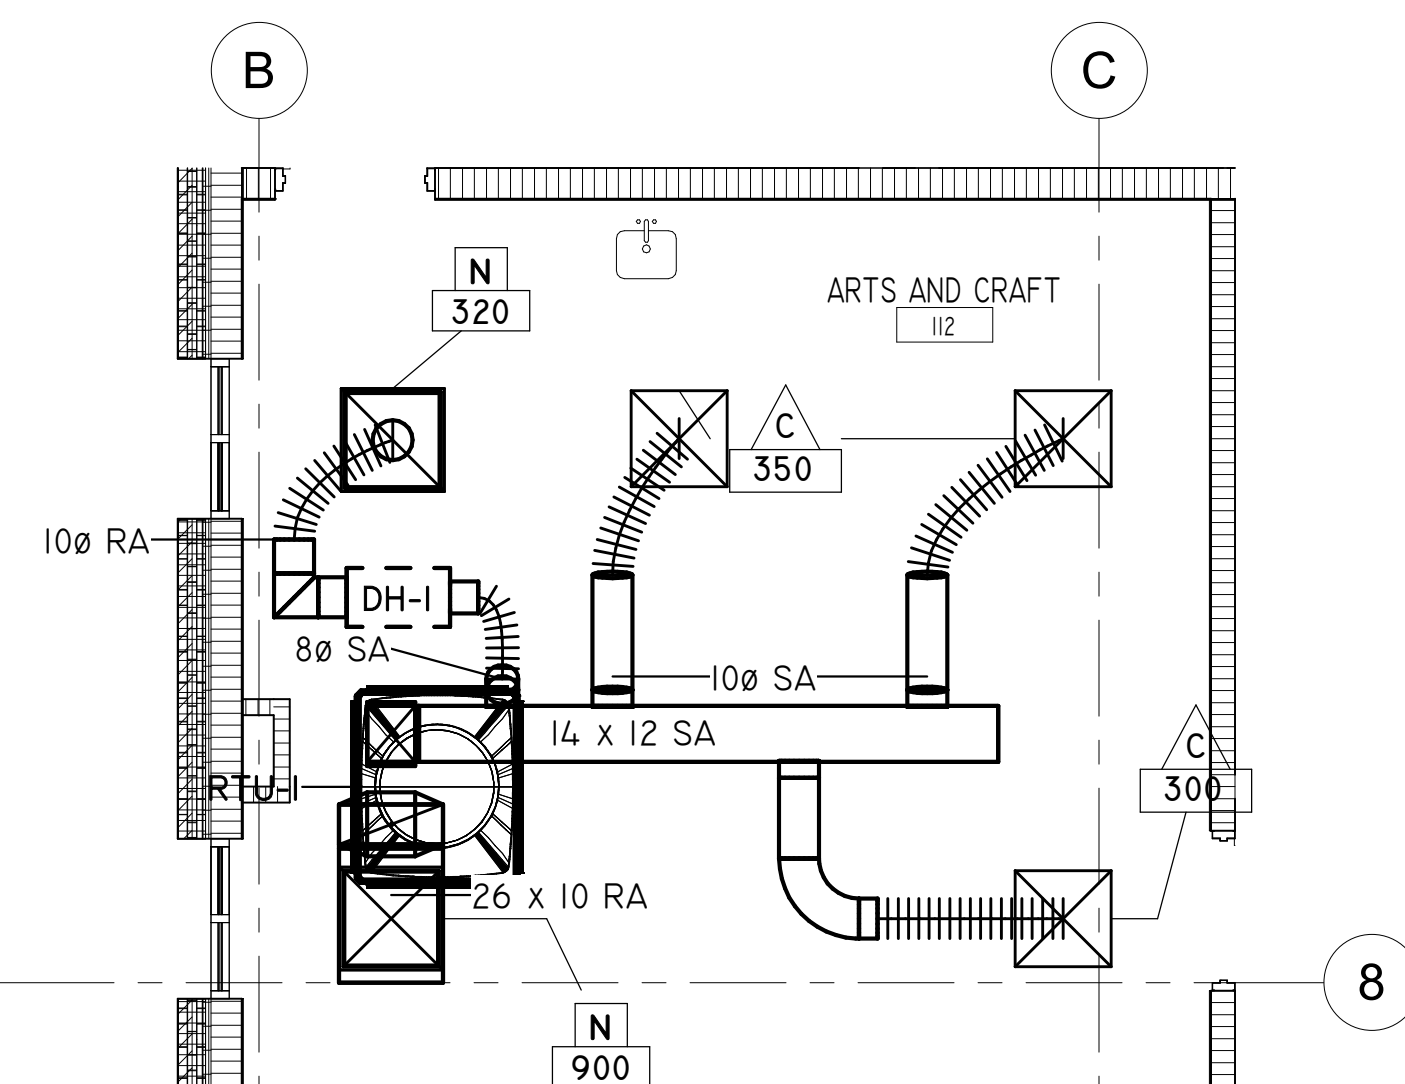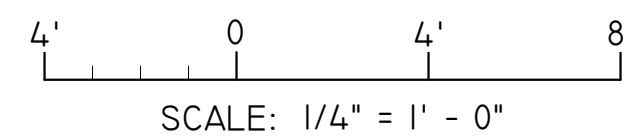


HVAC - ENLARGED COMMUNITY ROOMS

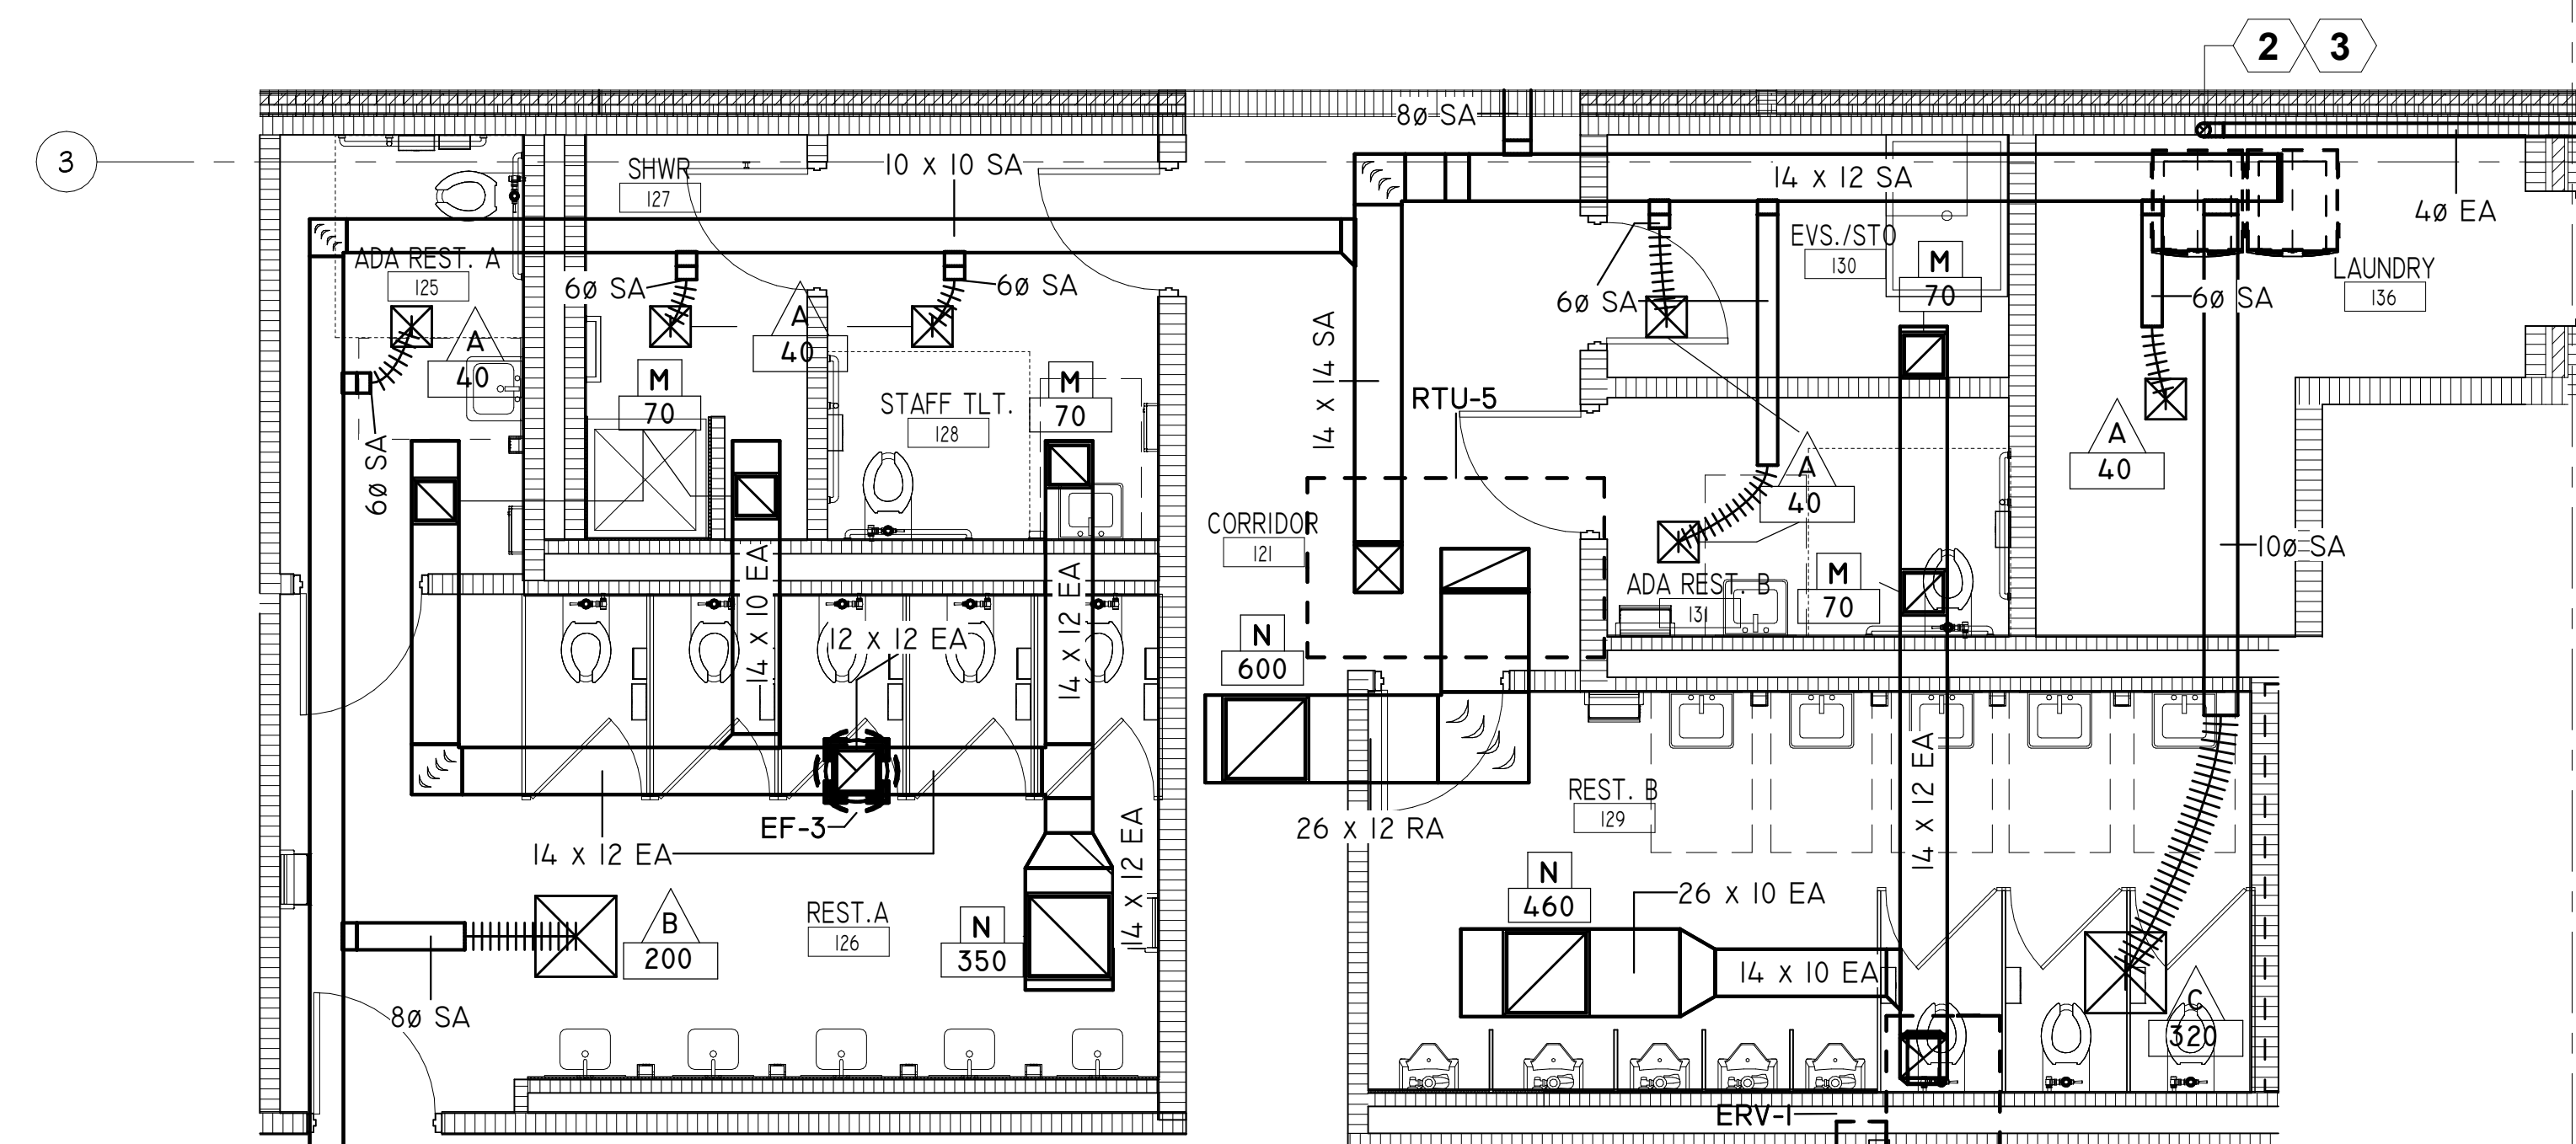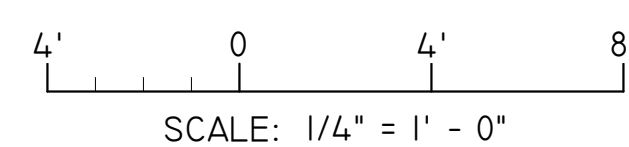

HVAC - ENLARGED RESTROOMS PLAN PHASE 2

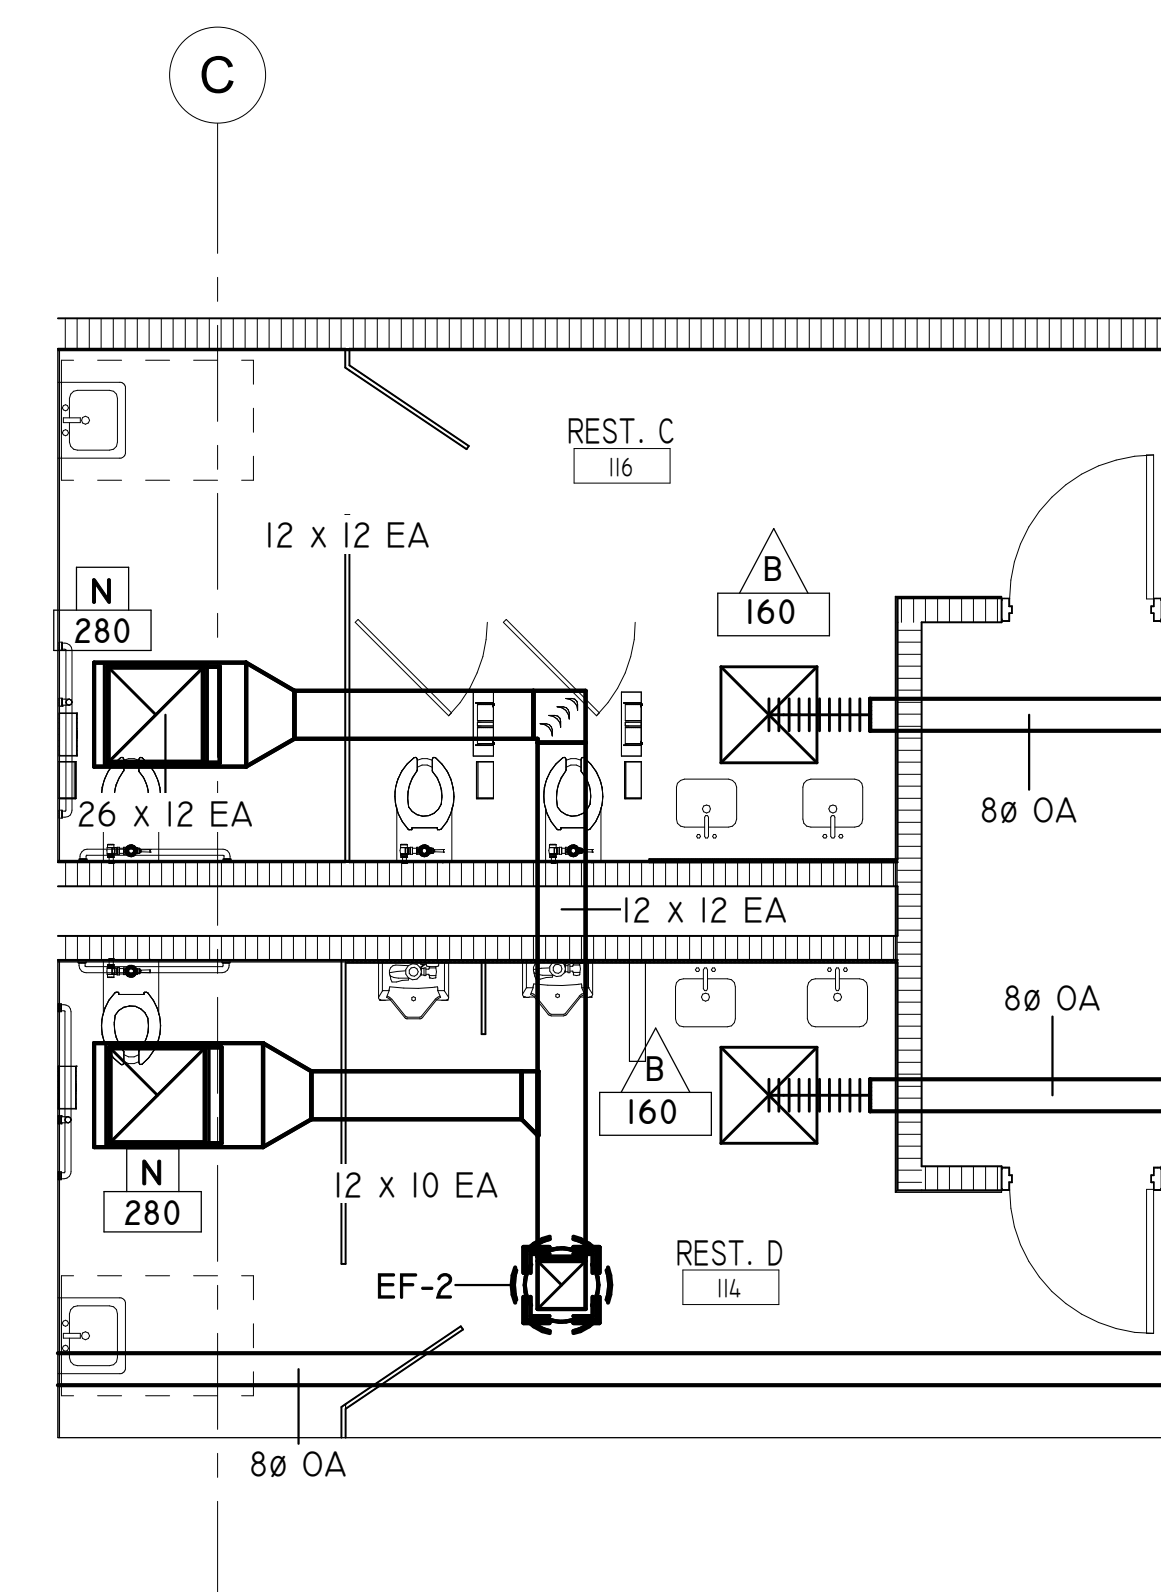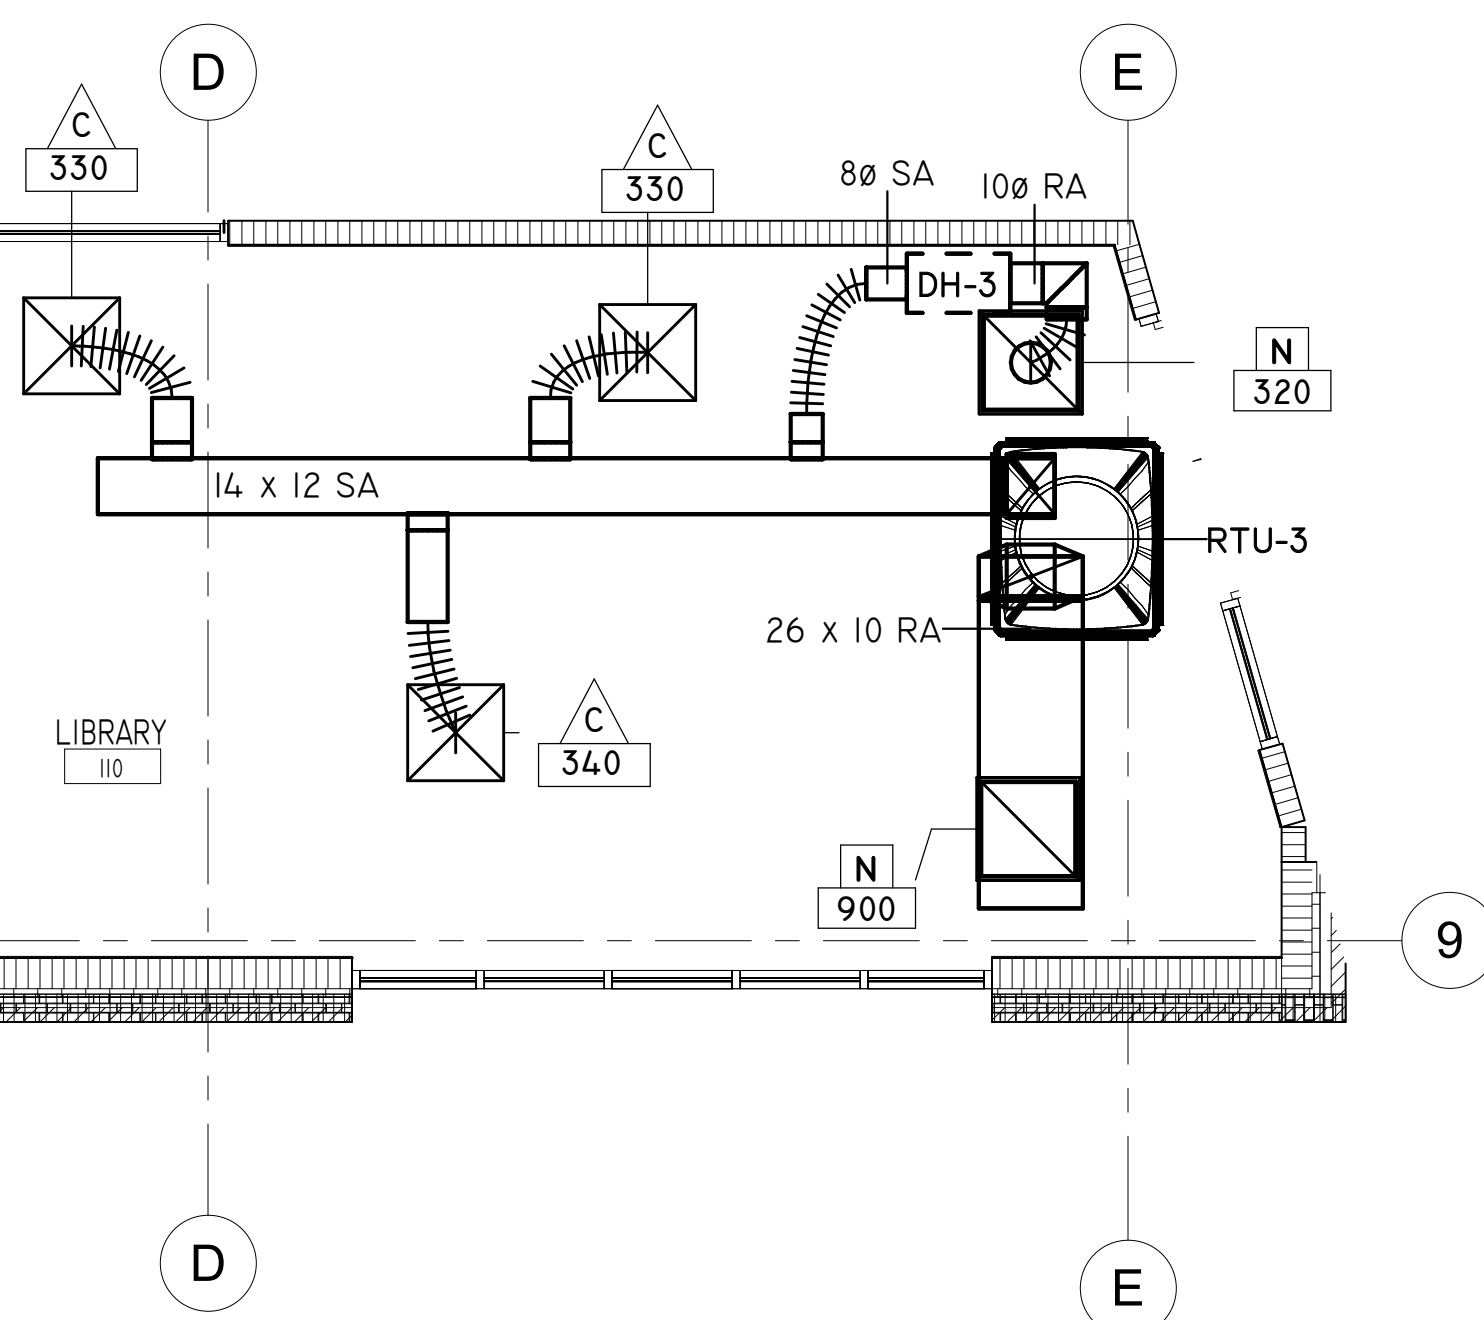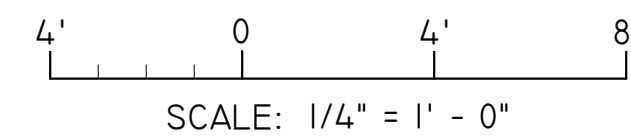

HVAC - ENLARGED RESTROOMS PLAN PHASE I

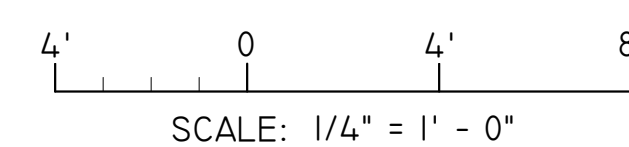

Printed copies of this document are not to be considered original, the original is digitally signed


SHEET NOTES	
KEY #	KEYNOTE TEXT
1	PROVIDE TITUS T-3 DIFFUSER CONTROLLED BY LOCAL THERMOSTAT AS INDICATED
2	PROVIDE INO-VATE TECHNOLOGIES DRYER BOX IN WALL FOR DRYER CONNECTION
3	PROVIDE UL705 POWER VENTILATOR IN 120V. CONTRACTOR SHALL FIELD VERIFY DRYER EXHAUST AMOUNT AND MATCH FAN FLOW TO THIS VOLUME. INTERLOCK W/ DRYER OPERATION.

GODWIN MILLS CAWOOD, LLC.
720 Bayfront Parkway, Suite 200
Pensacola, FL 32502
T 850.432.0706
GMCNETWORK.COM
Gerald Steven Jernigan -
Qualifying Agent
FL Architect AR 0009953

**FRICKER RESOURCE CENTER
RENOVATION PROJECT**

900 N F St, Pensacola, FL 32501-2887

GMC # APEN250016

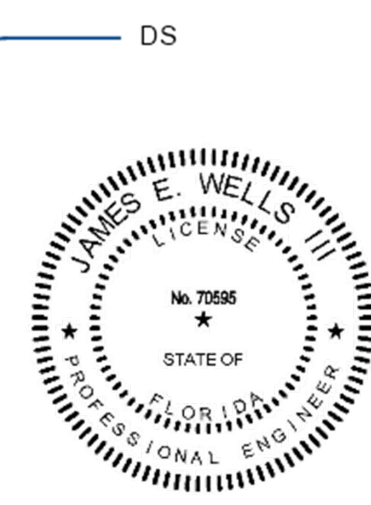

ENLARGED FLOOR PLANS

M3.1

WESTERN
ENGINEERING

W3 Engineering Inc.
110 E. WRIGHT ST.
PENSACOLA, FL 32502
T: (850)629-8270
F: (888)478-4898
FL P.E. #: 70595
FL AUTHORIZATION #: 31078

ISSUE	DATE
PERMIT SET	12/08/2025
DRAWN BY:	Author
CHECKED BY:	Checker

**FRICKER RESOURCE CENTER
RENOVATION PROJECT**

900 N F St, Pensacola, FL 32501-2887

GMC # APEN250016



ENLARGED FLOOR PLANS


M3.3

DocuSigned by:
10146CEE80E745E
DS



4/6/2026 | 14:01:32 PDT

W3 Engineering Inc.
110 E. WRIGHT ST.
PENSACOLA, FL 32502
T: (850)629-8270
F: (888)478-4898
FL P.E. #: 70595
FL AUTHORIZATION #: 31078

FL AUTHORIZATION #: 31078


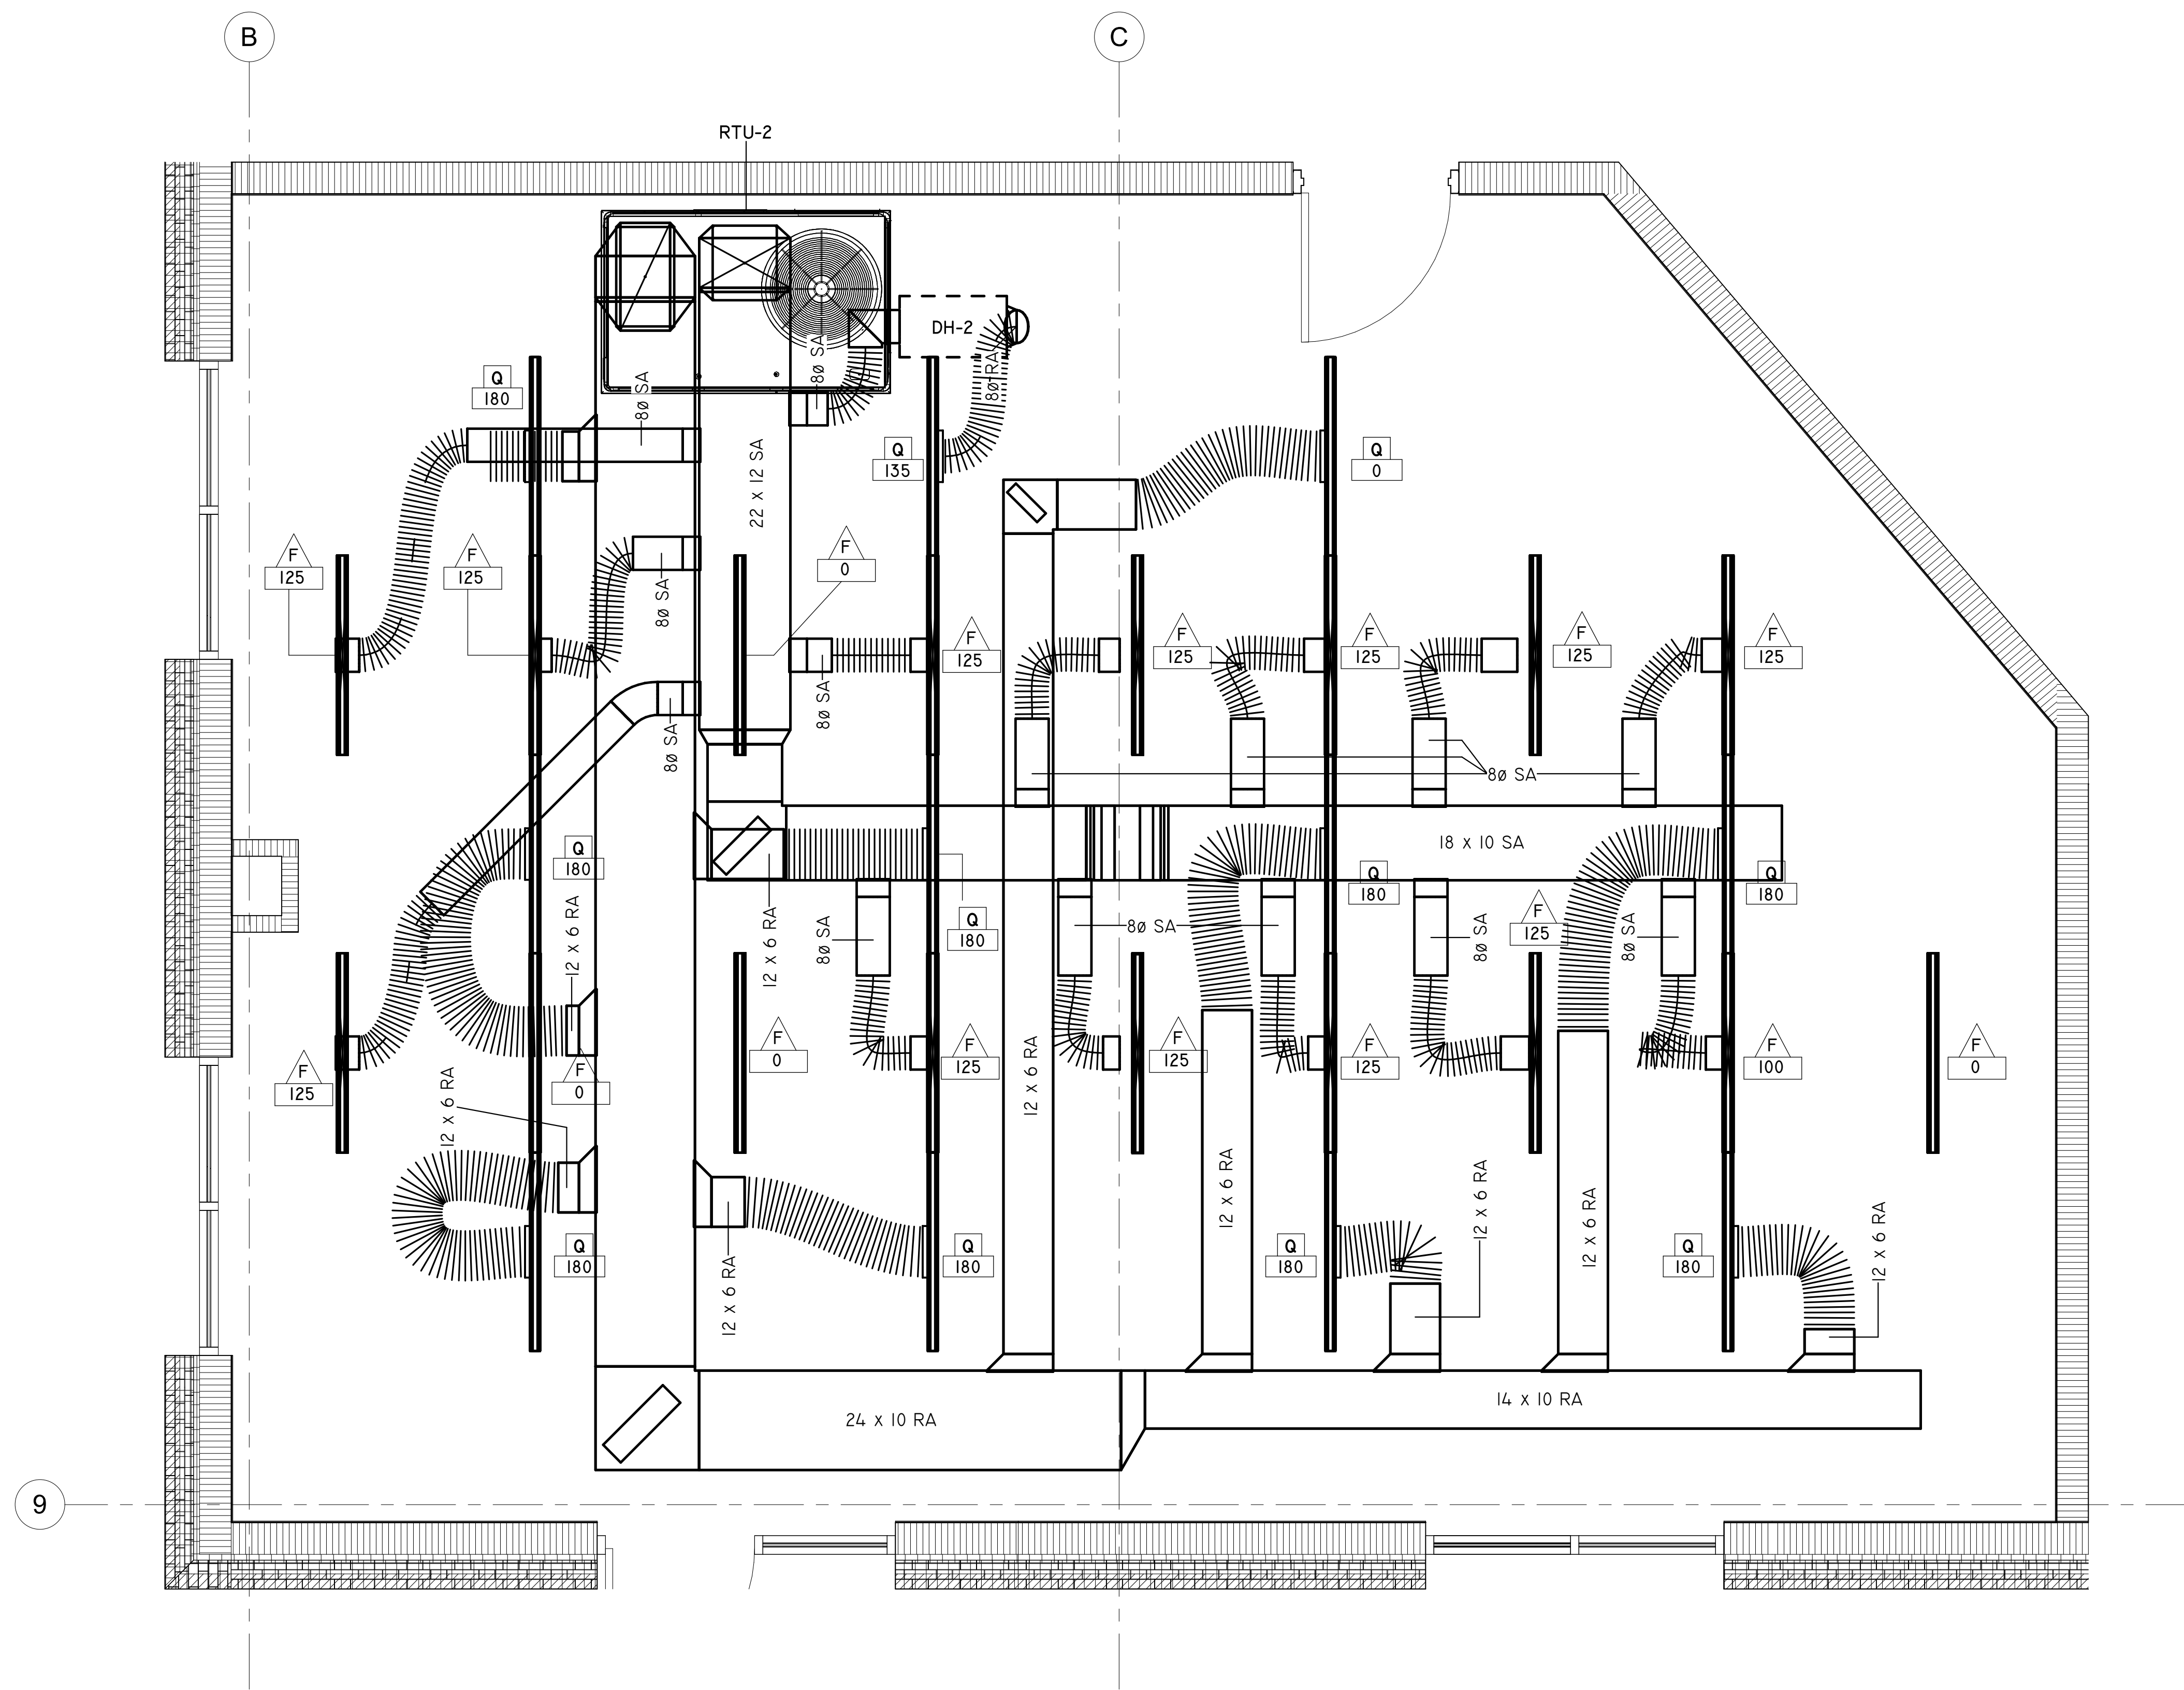


6 HVAC - ENLARGED MULTIPURPOSE ROOM

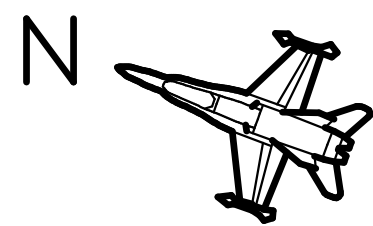




2' 0 2' 4'

  SCALE: 1/2" = 1' - 0"







NO SCALE

   

NOT TO SCALE

  

G O O D W Y N M I L L S C A W O O D , L L C .
720 Bayfront Parkway, Suite 200
Pensacola, FL 32502
T 850.432.0706
G M C N E T W O R K . C O M
Gerald Steven Jernigan -
Qualifying Agent
FL Architect AR 0009953

ISSUE	DATE
PERMIT SET	12/08/2025
DRAWN BY:	ACL

**FRICKER RESOURCE CENTER
RENOVATION PROJECT**

900 N F St, Pensacola, FL 32501-2887

GMC # APEN250016



HVAC DETAILS

M5.3

Printed copies of this document are not to be considered original, the original is digitally signed

NOTES:

- PROVIDE BACNET COMMUNICATIONS CARD.
- PROVIDE DESICCANT WHEEL STYLE ERV.

NOTES:

DEHUMIDIFIER SCHEDULE									
MARK	REFRIGERANT TYPE	CAPACITY	ENERGY PERFORMANCE	FLOW DATA		ELECTRICAL DATA			DESCRIPTION
				AIR FLOW	E. S.P	VOLTAGE	AMPS	HZ	
DH-1	R-410A	90 PINTS	6.1 PINTS/KWH	320	0.00 IN-WG	120	5.3	60	BASIS OF DESIGN: HONEYWELL DR90A3000
DH-2	R-410A	90 PINTS	6.1 PINTS/KWH	320	0.00 IN-WG	120	5.3	60	BASIS OF DESIGN: HONEYWELL DR90A3000
DH-3	R-410A	90 PINTS	6.1 PINTS/KWH	320	0.00 IN-WG	120	5.3	60	BASIS OF DESIGN: HONEYWELL DR90A3000
DH-4	R-410A	90 PINTS	6.1 PINTS/KWH	320	0.00 IN-WG	120	5.3	60	BASIS OF DESIGN: HONEYWELL DR90A3000
DH-5	R-410A	120 PINTS	6.1 PINTS/KWH	400	0.00 IN-WG	120	7.3	60	BASIS OF DESIGN: HONEYWELL DR120A3000
DH-6	R-410A	65 PINTS	4.7 PINTS/KWH	160	0.00 IN-WG	120	5.2	60	BASIS OF DESIGN: HONEYWELL DR65A3000
DH-7	R-410A	90 PINTS	6.1 PINTS/KWH	320	0.00 IN-WG	120	5.3	60	BASIS OF DESIGN: HONEYWELL DR90A3000
DH-8	R-410A	90 PINTS	6.1 PINTS/KWH	320	0.00 IN-WG	120	5.3	60	BASIS OF DESIGN: HONEYWELL DR90A3000
DH-9	R-410A	90 PINTS	6.1 PINTS/KWH	320	0.00 IN-WG	120	5.3	60	BASIS OF DESIGN: HONEYWELL DR90A3000

-- PROVIDE SINGLE POINT POWER CONNECTION.

**FRICKER RESOURCE CENTER
RENOVATION PROJECT**

ISSUE	DATE
PERMIT SET	12/08/2025
DRAWN BY: ACL	
CHECKED BY: JEW3	



HVAC SCHEDULES

W3 Engineering Inc.
110 E. WRIGHT ST.
PENSACOLA, FL 32502
T: (850)629-8270
F: (888)478-4898
FL P.E. #: 70595
FL AUTHORIZATION #: 31078

M6.2

GMC # APEN250016

4/6/2026 | 14:01:32 PDT

