

| INDEX OF DRAWINGS |                                                     |            |               |
|-------------------|-----------------------------------------------------|------------|---------------|
|                   | SHEET NAME                                          | ISSUE DATE | REVISION DATE |
| O.0 TITLE         |                                                     |            |               |
| T1                | TITLE SHEET                                         | 12/08/2025 |               |
| O.1 GENERAL       |                                                     |            |               |
| G1.01             | INDEX OF DRAWINGS/ BASIS OF DESIGN LEGEND           | 12/08/2025 | 05/14/2026    |
| G1.02             | GENERAL NOTES                                       | 12/08/2025 |               |
| G1.03             | GENERAL INFORMATION                                 | 12/08/2025 |               |
| G1.11             | ACCESSIBILITY INFORMATION                           | 12/08/2025 | 06/16/2026    |
| G1.12             | PHASING PLANS                                       | 12/08/2025 | 04/13/2026    |
| G1.14             | GRANT DIVISION                                      | 12/08/2025 |               |
| G1.20             | PARTITION TYPES                                     | 12/08/2025 |               |
| I.0 CIVIL         |                                                     |            |               |
| C1.0              | EXISTING SITE, DEMOLITION & EROSION CONTROL PLAN    | 12/08/2025 |               |
| C1.1              | EROSION CONTROL DETAILS                             | 12/08/2025 |               |
| C1.2              | NPDES - STORMWATER POLLUTION PREVENTION PLAN        | 12/08/2025 |               |
| C2.0              | SITE LAYOUT & DIMENSION PLAN                        | 12/08/2025 | 02/09/2026    |
| C2.1              | SITE DETAILS                                        | 12/08/2025 | 02/09/2026    |
| C3.0              | GRADING & DRAINAGE PLAN                             | 12/08/2025 |               |
| C3.1              | GRADING & DRAINAGE DETAILS                          | 12/08/2025 |               |
| C4.0              | UTILITY PLAN                                        | 12/08/2025 | 06/16/2026    |
| C4.1              | UTILITY DETAILS                                     | 12/08/2025 | 06/16/2026    |
| C5.0              | LANDSCAPE PLAN                                      | 12/08/2025 | 04/07/2026    |
| L.5 LIFE SAFETY   |                                                     |            |               |
| L51.00            | LIFE SAFETY - CODE STUDY                            | 12/08/2025 | 04/13/2026    |
| L51.01            | LIFE SAFETY PLAN - FIRST FLOOR PLAN                 | 12/08/2025 | 05/01/2026    |
| 2.0 DEMOLITION    |                                                     |            |               |
| D1.01             | DEMOLITION - SITE PLAN                              | 12/08/2025 |               |
| D1.02             | DEMOLITION - FLOOR PLAN                             | 12/08/2025 | 06/16/2026    |
| D1.03             | DEMOLITION - REFLECTED CEILING PLAN                 | 12/08/2025 |               |
| D1.04             | DEMOLITION - REFLECTED CEILING PLAN - HIGH CEILINGS | 12/08/2025 |               |
| D1.05             | DEMOLITION - LOW ROOF PLAN                          | 12/08/2025 |               |
| D1.06             | DEMOLITION - HIGH ROOF PLAN                         | 12/08/2025 |               |
| D1.07             | DEMOLITION ELEVATIONS                               | 12/08/2025 | 04/13/2026    |
| 3.0 ARCHITECTURE  |                                                     |            |               |
| A1.00             | NEW WORK - SITE PLAN                                | 12/08/2025 | 05/01/2026    |
| A1.01             | NEW WORK NOTED - FLOOR PLAN                         | 12/08/2025 | 05/14/2026    |
| A1.03             | NEW WORK DIMENSION - FLOOR PLAN                     | 12/08/2025 | 08/04/2026    |
| A1.12             | ENLARGED PLANS RESTROOMS                            | 12/08/2025 | 06/16/2026    |
| A1.13             | ENLARGED PLANS RESTROOMS                            | 12/08/2025 | 06/16/2026    |
| A1.14             | ENLARGED PLANS AND INTERIOR ELEVATIONS              | 12/08/2025 | 05/01/2026    |
| A1.15             | ENLARGED PLANS AND INTERIOR ELEVATIONS              | 12/08/2025 | 05/01/2026    |
| A1.16             | ENLARGED PLANS AND INTERIOR ELEVATIONS              | 12/08/2025 | 04/13/2026    |
| A1.17             | ENLARGED PLANS AND INTERIOR ELEVATIONS              | 12/08/2025 |               |
| A1.18             | ENLARGED PLANS AND INTERIOR ELEVATIONS              | 12/08/2025 |               |
| A1.19             | GYMNASIUM ELEVATIONS                                | 12/08/2025 | 05/01/2026    |
| A1.20             | WEIGHT ROOM ELEVATIONS                              | 12/08/2025 |               |
| A2.01             | NEW WORK - REFLECTED CEILING PLAN                   | 12/08/2025 |               |
| A2.02             | TYPICAL CEILING DETAILS                             | 12/08/2025 |               |
| A3.01             | NEW WORK - LOW ROOF PLAN                            | 12/08/2025 | 04/13/2026    |
| A3.02             | NEW WORK - HIGH ROOF PLAN                           | 12/08/2025 |               |
| A3.03             | ROOF & CANOPY DETAILS                               | 12/08/2025 |               |
| A3.04             | ROOF SECTION DETAILS                                | 12/08/2025 |               |
| A3.05             | ROOF SADDLE FLASHING DETAILS                        | 12/08/2025 |               |
| A4.01             | EXTERIOR ELEVATIONS                                 | 12/08/2025 | 05/01/2026    |
| A5.01             | BUILDING SECTIONS                                   | 12/08/2025 |               |
| A5.02             | BUILDING SECTIONS                                   | 12/08/2025 |               |
| A5.03             | BUILDING SECTIONS                                   | 12/08/2025 |               |
| A5.11             | WALL SECTIONS                                       | 12/08/2025 |               |
| A5.12             | WALL SECTIONS                                       | 12/08/2025 |               |
| A5.13             | WALL & CANOPY ENTRY SECTIONS                        | 12/08/2025 | 05/01/2026    |
| A5.41             | EXTERIOR STEPS AND RAILING DETAILS                  | 12/08/2025 | 05/01/2026    |
| A5.42             | DUMPSTER ENCLOSURE DETAIL & MECH FENCE DETAIL       | 12/08/2025 |               |
| A6.01             | DOOR SCHEDULE, LEGEND, & DETAILS                    | 12/08/2025 | 05/01/2026    |
| A6.02             | DOOR HEAD, JAMB AND SILL DETAILS                    | 12/08/2025 |               |
| A6.03             | MISCELLANEOUS                                       | 12/08/2025 |               |
| A6.11             | STOREFRONT & WINDOW TYPES                           | 12/08/2025 |               |
| A6.12             | INTERIOR STOREFRONT HEAD, JAMB AND SILL DETAILS     | 12/08/2025 |               |
| A6.12B            | EXTERIOR STOREFRONT HEAD, JAMB AND SILL DETAILS     | 12/08/2025 |               |
| A7.11             | MILLWORK DETAILS                                    | 12/08/2025 | 05/01/2026    |
| A8.01             | FINISH LEGEND/ FLOORING DETAILS                     | 12/08/2025 |               |
| A8.02             | FINISH SCHEDULE AND SIGNAGE                         | 12/08/2025 | 05/04/2026    |
| A8.03             | FINISH FLOOR PLAN                                   | 12/08/2025 | 05/01/2026    |
| A8.05             | FURNITURE PLAN AND SCHEDULE                         | 12/08/2025 | 05/01/2026    |
| 4.0 STRUCTURAL    |                                                     |            |               |
| SD.101            | STRUCTURAL - DEMOLITION GROUND FLOOR PLAN           | 12/08/2025 | 08/04/2026    |
| SD.102            | STRUCTURAL - DEMOLITION LOW ROOF FRAMING            | 12/08/2025 |               |
| S.001             | GENERAL NOTES                                       | 12/08/2025 |               |
| S.002             | WIND LOAD DIAGRAM                                   | 12/08/2025 |               |
| S.003             | SPECIAL INSPECTION PLAN                             | 12/08/2025 | 05/14/2026    |
| S.004             | SPECIAL INSPECTION PLAN CONTINUED                   | 12/08/2025 |               |
| S.005             | SPECIAL INSPECTION PLAN CONTINUED                   | 12/08/2025 | 05/14/2026    |

| INDEX OF DRAWINGS   |                                                       |            |               |
|---------------------|-------------------------------------------------------|------------|---------------|
|                     | SHEET NAME                                            | ISSUE DATE | REVISION DATE |
| S.101               | FOUNDATION PLAN                                       | 12/08/2025 | 08/04/2026    |
| S.101.1             | SLAB-ON-GRADE PLAN                                    | 12/08/2025 |               |
| S.102               | LOW ROOF FRAMING PLAN                                 | 12/08/2025 |               |
| S.103               | HIGH ROOF FRAMING PLAN                                | 12/08/2025 |               |
| S.410               | FOUNDATION SECTIONS AND DETAILS                       | 12/08/2025 |               |
| S.420               | LOW ROOF FRAMING DETAILS                              | 12/08/2025 |               |
| S.421               | LOW ROOF FRAMING DETAILS                              | 12/08/2025 |               |
| S.422               | LOW ROOF FRAMING DETAILS                              | 12/08/2025 |               |
| S.430               | HIGH ROOF FRAMING SECTIONS AND DETAILS                | 12/08/2025 |               |
| S.501               | TYPICAL FOUNDATION, SLAB AND STEEL DETAILS            | 12/08/2025 |               |
| S.502               | TYPICAL STEEL AND MASONRY DETAILS                     | 12/08/2025 |               |
| S.503               | MASONRY OPENING DETAILS IN EXISTING WALLS             | 12/08/2025 |               |
| 5.0 MECHANICAL      |                                                       |            |               |
| M0.1                | LEGEND & GENERAL NOTES                                | 12/08/2025 |               |
| M1.1                | HVAC DEMOLITION PLAN                                  | 12/08/2025 |               |
| M1.2                | HVAC NEW WORK FLOOR PLAN                              | 12/08/2025 |               |
| M1.3                | HVAC NEW WORK LOWER ROOF PLAN                         | 12/08/2025 |               |
| M1.4                | HVAC NEW WORK UPPER ROOF PLAN                         | 12/08/2025 |               |
| M2.1                | HVAC NEW WORK PIPING PLAN                             | 12/08/2025 |               |
| M2.2                | HVAC NEW WORK LOWER ROOF PIPING PLAN                  | 12/08/2025 |               |
| M2.3                | HVAC NEW WORK UPPER ROOF PIPING PLAN                  | 12/08/2025 |               |
| M3.1                | ENLARGED FLOOR PLANS                                  | 12/08/2025 |               |
| M3.2                | ENLARGED FLOOR PLANS                                  | 12/08/2025 |               |
| M3.3                | ENLARGED FLOOR PLANS                                  | 12/08/2025 |               |
| M5.1                | HVAC DETAILS                                          | 12/08/2025 |               |
| M5.2                | HVAC DETAILS                                          | 12/08/2025 |               |
| M5.3                | HVAC DETAILS                                          | 12/08/2025 |               |
| M6.1                | HVAC SCHEDULES                                        | 12/08/2025 |               |
| M6.2                | HVAC SCHEDULES                                        | 12/08/2025 |               |
| M7.1                | HVAC CONTROLS                                         | 12/08/2025 |               |
| 6.0 PLUMBING        |                                                       |            |               |
| P0.01               | PLUMBING LEGEND, ABBREVIATIONS, & NOTES               | 12/08/2025 |               |
| P1.01               | SANITARY PLUMBING DEMOLITION PLAN                     | 12/08/2025 |               |
| P1.02               | DOMESTIC PLUMBING DEMOLITION PLAN                     | 12/08/2025 |               |
| P1.11               | DOMESTIC PIPING NEW WORK ENLARGED PLAN WEST (WEST)    | 12/08/2025 | 06/16/2026    |
| P1.12               | DOMESTIC PIPING NEW WORK ENLARGED PLAN WEST (EAST)    | 12/08/2025 | 06/16/2026    |
| P1.21               | SANITARY PIPING NEW WORK ENLARGED PLAN - WEST         | 12/08/2025 | 06/16/2026    |
| P1.22               | SANITARY PIPING NEW WORK PLAN - EAST                  | 12/08/2025 | 06/16/2026    |
| P1.23               | SANITARY PIPING NEW WORK ROOF PLAN                    | 12/08/2025 | 08/04/2026    |
| P1.31               | NATURAL GAS PIPING NEW WORK PLAN                      | 12/08/2025 |               |
| P4.01               | PLUMBING NEW WORK ENLARGED PLAN - KITCHEN             | 12/08/2025 |               |
| P4.02               | PLUMBING NEW WORK ENLARGED PLAN - RESTROOM G/D        | 12/08/2025 | 06/16/2026    |
| P4.03               | PLUMBING NEW WORK ENLARGED PLAN - EAST RESTROOM       | 12/08/2025 | 06/16/2026    |
| P5.01               | GAS DETAILS                                           | 12/08/2025 |               |
| P5.02               | EQUIPMENT DETAILS                                     | 12/08/2025 |               |
| P5.03               | PIPE SUPPORT DETAILS                                  | 12/08/2025 |               |
| P6.01               | PLUMBING SCHEDULES                                    | 12/08/2025 |               |
| P9.01               | SANITARY RISER DIAGRAM                                | 12/08/2025 | 06/16/2026    |
| P9.02               | DOMESTIC RISER DIAGRAM                                | 12/08/2025 |               |
| P9.03               | NATURAL GAS RISER DIAGRAM                             | 12/08/2025 |               |
| 6.5 FIRE PROTECTION |                                                       |            |               |
| FP0.1               | FIRE PROTECTION LEGEND, AND DETAILS                   | 12/08/2025 |               |
| FP1.1               | FIRE PROTECTION 1ST FLOOR PLAN                        | 12/08/2025 |               |
| 7.0 ELECTRICAL      |                                                       |            |               |
| E0.01               | ELECTRICAL LEGENDS AND NOTES                          | 12/08/2025 |               |
| E0.11               | ELECTRICAL DEMOLITION FLOOR PLAN                      | 12/08/2025 |               |
| E0.12               | ELECTRICAL DEMOLITION RCP                             | 12/08/2025 |               |
| E0.13               | ELECTRICAL DEMOLITION ROOF PLAN                       | 12/08/2025 |               |
| E0.51               | ELECTRICAL SITE PLAN - NEW                            | 12/08/2025 |               |
| E1.01               | NEW POWER PLAN                                        | 12/08/2025 |               |
| E1.02               | NEW ENLARGED KITCHEN POWER PLAN AND SCHEDULES         | 12/08/2025 |               |
| E2.01               | NEW MECH POWER PLAN                                   | 12/08/2025 |               |
| E2.02               | NEW MECH POWER PLAN - ROOF                            | 12/08/2025 |               |
| E3.01               | NEW FIRE ALARM PLAN                                   | 12/08/2025 |               |
| E4.01               | NEW LIGHTING PLAN                                     | 12/08/2025 |               |
| E5.01               | ELECTRICAL DETAILS                                    | 12/08/2025 |               |
| E5.02               | ELECTRICAL DETAILS                                    | 12/08/2025 |               |
| E5.03               | GROUNDING DETAILS & FIRE ALARM RISER                  | 12/08/2025 |               |
| E5.04               | LIGHTING CONTROL DETAILS                              | 12/08/2025 |               |
| E6.01               | POWER RISER DIAGRAM                                   | 12/08/2025 |               |
| E7.01               | PANEL SCHEDULES                                       | 12/08/2025 |               |
| E7.02               | PANEL SCHEDULES                                       | 12/08/2025 |               |
| E7.03               | MECHANICAL EQUIPMENT SCHEDULE                         | 12/08/2025 |               |
| E7.04               | LIGHTING SCHEDULES                                    | 12/08/2025 |               |
| 8.0 TELECOM         |                                                       |            |               |
| T0.01               | COMMUNICATIONS LEGENDS & NOTES                        | 12/08/2025 |               |
| T0.10               | COMMUNICATIONS FLOOR PLANS                            | 12/08/2025 |               |
| T1.01               | COMMUNICATIONS FLOOR PLANS                            | 12/08/2025 |               |
| T1.05               | COMMUNICATIONS DEMOLITION FLOOR PLAN                  | 12/08/2025 |               |
| T1.50               | COMMUNICATIONS FLOOR PLANS                            | 12/08/2025 |               |
| T2.01               | COMMUNICATIONS TYPICAL DETAILS                        | 12/08/2025 |               |
| T2.02               | COMMUNICATIONS TYPICAL DETAILS                        | 12/08/2025 |               |
| T2.03               | COMMUNICATIONS TYPICAL DETAILS                        | 12/08/2025 |               |
| T2.04               | COMMUNICATIONS TYPICAL DETAILS                        | 12/08/2025 |               |
| T2.05               | COMMUNICATIONS TYPICAL DETAILS                        | 12/08/2025 |               |
| T2.06               | COMMUNICATIONS TYPICAL DETAILS                        | 12/08/2025 |               |
| T3.01               | VOICE SYSTEM SINGLE LINE CONFIGURATION DIAGRAM        | 12/08/2025 |               |
| T3.02               | DATA AND TV SYSTEM SINGLE LINE CONFIGURATION DIAGRAMS | 12/08/2025 |               |
| T4.01               | COMMUNICATION CLOSET (CC) ENLARGED FLOOR PLAN         | 12/08/2025 |               |
| T4.02               | COMMUNICATIONS RACK ELEVATIONS                        | 12/08/2025 |               |


158

| BASIS OF DESIGN - EXTERIOR<br>FLORIDA PRODUCT APPROVALS |                               |                                        |                              |                            |
|---------------------------------------------------------|-------------------------------|----------------------------------------|------------------------------|----------------------------|
| ELEMENT                                                 | MANUFACTURER                  | MODEL                                  | FINISH                       | FLORIDA PRODUCT APPROVAL # |
| STOREFRONT                                              | OLD CASTLE                    | FB-5750 T StormMax FG-2000             | EXTERIOR: DARK BRONZE        | FL# 20685.3                |
| GLAZING                                                 | GUARDIAN                      | SUNGUARD (LOW E)                       | SUPERNEUTRAL 88 ON GRAY      | -                          |
| GLAZING SEALANT                                         | -                             | -                                      | TO MATCH GLAZING FRAME       | -                          |
| FFFS                                                    | STQ                           | STQ THERM CL                           | FINISH: SANDBLAST COLOR: TBD | FL# 21034-R2               |
| SINGLE PLY ROOF MEMBRANE                                | JOHNS MANVILLE                | JM PVC MEMBRANE ADHESIVE (LOW VOC)     | WHITE (R)                    | FL16758-R30                |
| SINGLE PLY ROOF MEMBRANE                                | JOHNS MANVILLE                | JM PVC MEMBRANE ADHESIVE (LOW VOC)     | GREY (FOR CANOPES)           | FL16758-R30                |
| METAL SOFFIT                                            | PAC-CLAD                      | FLUSH & REVEAL SOFFIT WITH NARROW VENT | BURNISHED SLATE              | FL23157-R2                 |
| SLIDING DOOR (BI-PART) STOREFRONT                       | STANLEY                       | DURA STORM - Impact Bi-Part 3000       | BRONZE                       | FI# 41992.3                |
| HOLLOW METAL DOORS AND FRAMES                           | CECO DOOR PRODUCTS ASSA ABL0Y | SINGLE LEAF AND DOUBLE LEAF            | PRIMED                       | FL4553-R15                 |

CONTRACTOR SHALL MAINTAIN ON THE SITE THE FOLLOWING:  
1. COPY OF THE PRODUCT APPROVAL, INCLUDING PERFORMANCE CHARACTERISTICS WHICH THE PRODUCT WAS TESTED AND CERTIFIED TO COMPLY WITH.  
3. COPY OF THE APPLICABLE MANUFACTURERS INSTALLATION REQUIREMENTS.  
PRODUCT SUBSTITUTION SHALL BE MADE SUBJECT TO FULL COMPLIANCE WITH THE CRITERIA NOTED HEREON. ANY SUCH SUBSTITUTIONS SHALL BE SUBJECT TO PRIOR APPROVAL BY THE DESIGN PROFESSIONAL AND THE LOCAL BUILDING AUTHORITY HAVING JURISDICTION.


| BASIS OF DESIGN - INTERIOR        |               |                                   |                              |     |
|-----------------------------------|---------------|-----------------------------------|------------------------------|-----|
| STOREFRONT                        | YKK           | YES 40 FS                         | INTERIOR: YBSN - DARK BRONZE | -   |
| SLIDING DOOR (BI-PART) STOREFRONT | STANLEY       | DURA GLIDE NON-IMPACT 3000 F.B.O. | BRONZE                       | N/A |
| TRANSACTION WINDOW                | C.R. LAURENCE | MODEL D1031 INTERIOR USE          | DURANODIC BRONZE             | N/A |

NOTE: CONTRACTOR TO PROVIDE SAMPLES PRIOR TO ORDERING FOR OWNER AND ARCHITECT'S REVIEW.

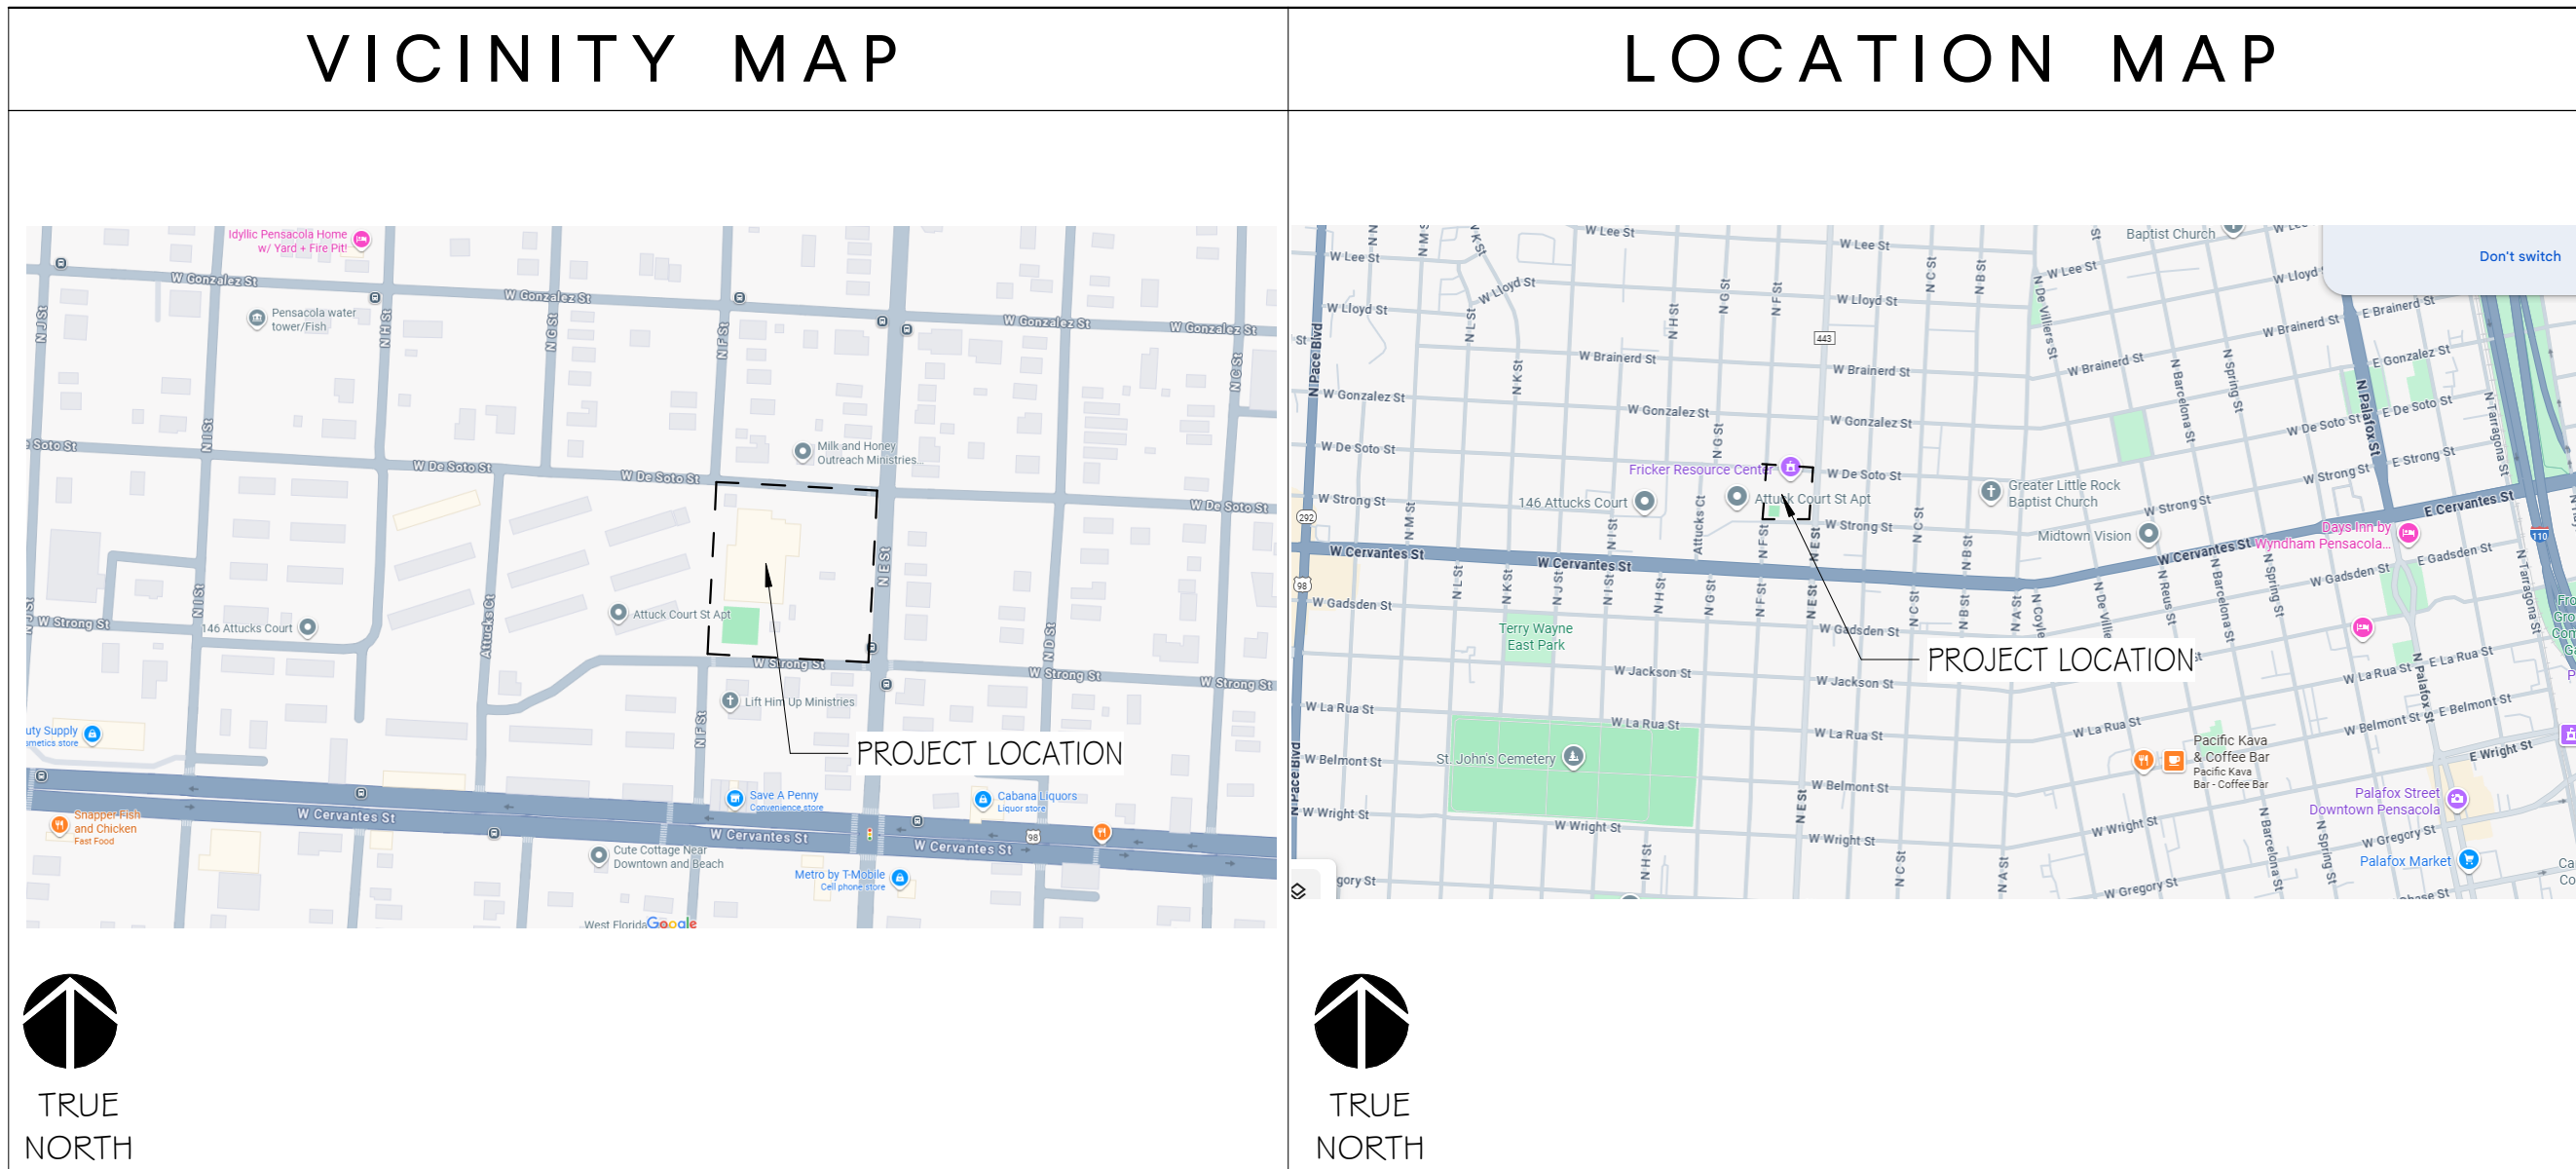



1 NEW WORK - DIMENSION PLAN  
A1.03 SCALE: 1/8" = 1'-0"

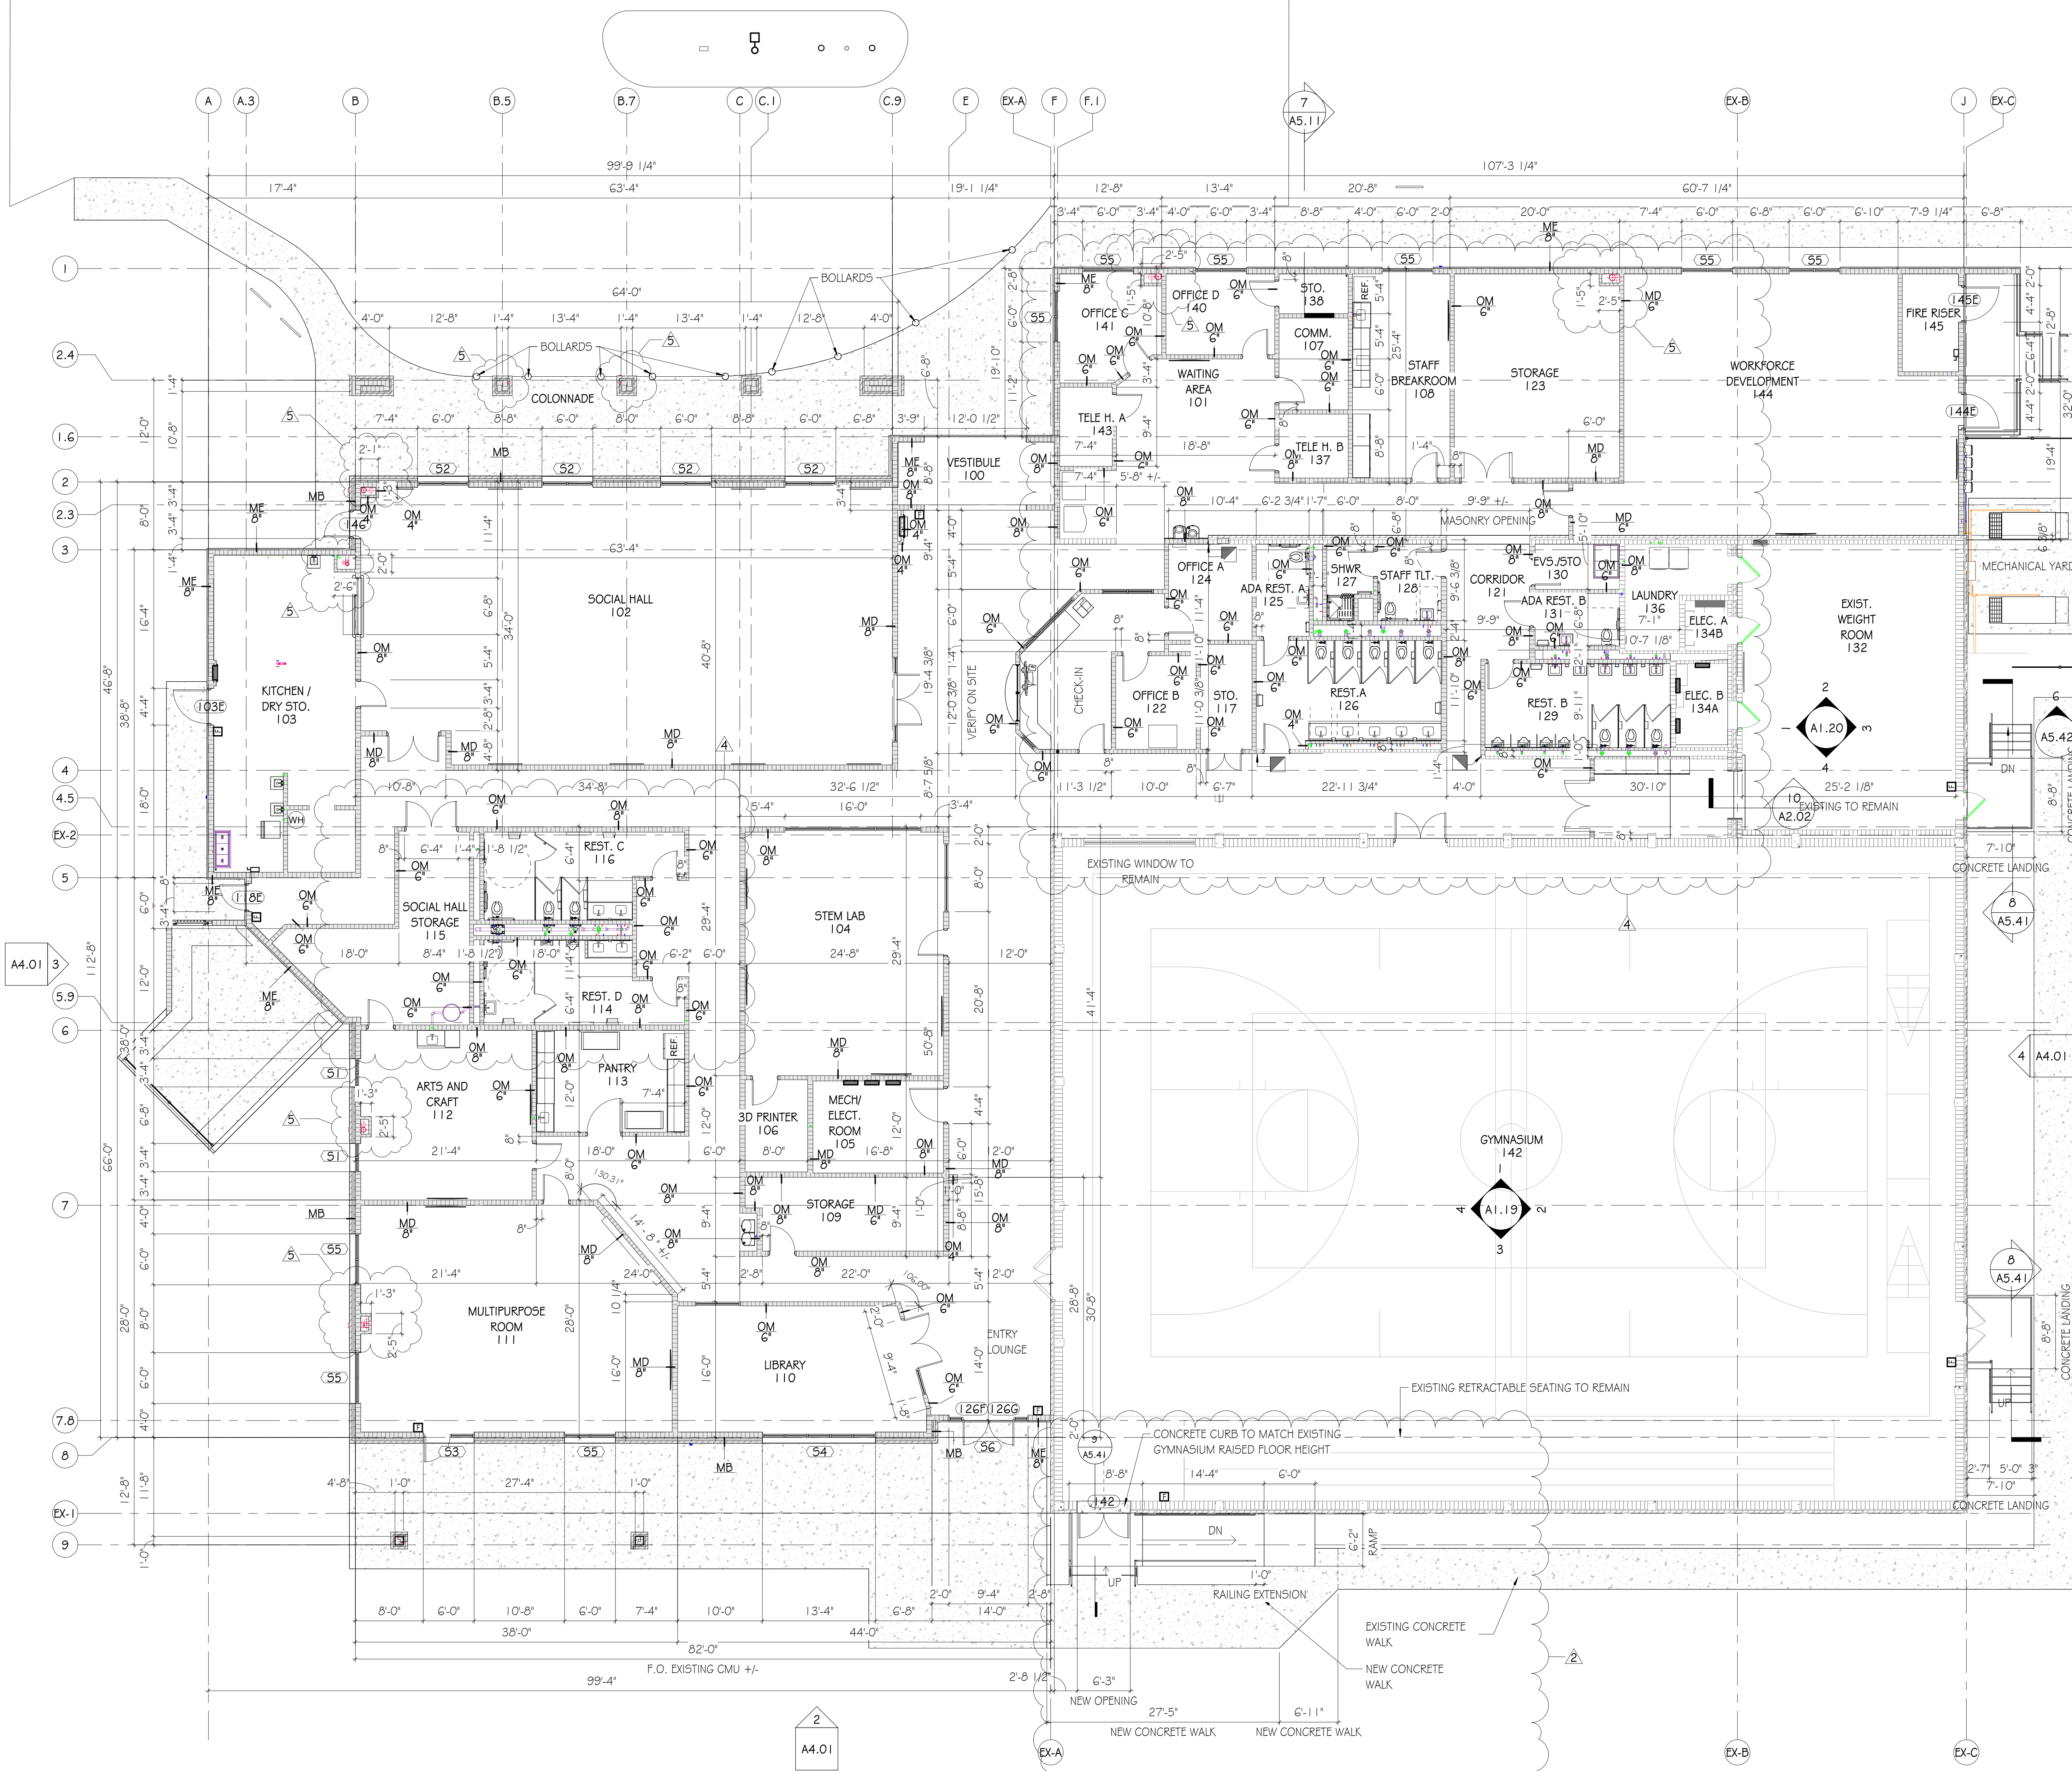

## FLOOR PLAN LEGEND

- EXISTING DOOR FRAME TO REMAIN, DOOR PANEL TO BE REPLACED
- NEW DOOR & FRAME
- NEW PARTITION & PARTITION TAG; SEE G.1.21 FOR PARTITION TYPES
- EXISTING PARTITION TO REMAIN
- NEW FIRE EXTINGUISHER CABINET
- EXISTING FIRE EXTINGUISHER CABINET
- EXISTING ROOM - SEE INTERIORS FOR EXTENT OF RENOVATIONS
- NEW ROOM / EXISTING ROOM TO BE RENOVATED ROOM NAME / NUMBER
- WINDOW; SEE WINDOW TYPES AG.01
- ELEVATION MARK SHEET WHERE ELEVATION IS LOCATED
- SECTION DETAIL MARK SHEET WHERE SECTION DETAIL IS LOCATED
- ALIGN NEW FINISH WITH EXISTING
- FIRE ALARM PULL STATION


## PARTITION KEY

|                                                                       |                                                                                      |                                                                                         |
|-----------------------------------------------------------------------|--------------------------------------------------------------------------------------|-----------------------------------------------------------------------------------------|
| TYPE 1G<br>3 5/8" METAL STUDS                                         | 1G                                                                                   | TYPE 1G<br>6" METAL STUDS                                                               |
| TYPE 1S<br>4" METAL CH STUDS                                          | 1S                                                                                   | TYPE 1S<br>2 1/2" METAL CH STUDS                                                        |
| TYPE OM<br>8" CMU                                                     | OM                                                                                   | TYPE OM<br>4" CMU                                                                       |
| TYPICAL PARTITION<br>(SHOWN THUS)                                     |                                                                                      | VARIANT PARTITION<br>(SHOWN THUS)                                                       |
| STANDARD FRAMING<br>3 5/8" METAL STUDS<br>4" METAL CH STUDS<br>8" CMU | PARTITIONS USE STANDARD<br>FRAMING EXCEPT WHERE VARIANT<br>FRAMING SIZE IS INDICATED | VARIANT FRAMING<br>WHERE APPLICABLE, SIZE IS<br>SHOWN IN INCHES BELOW<br>PARTITION TYPE |

## GENERAL NOTES

- ALL DIMENSIONS ARE TO FACE OF CMU UNLESS OTHERWISE NOTED.
- WALL THICKNESSES SHOWN ARE NOMINAL. WALL TYPES ARE DESIGNATED BY TAGS; REFER TO WALL TYPE LEGEND AND DETAILS.
- FURNITURE SHOWN FOR REFERENCE ONLY. NOT IN CONTRACT.
- UNLESS OTHERWISE NOTED, ALL FLOOR TILE SHALL BE CENTERED IN ROOM.
- UNLESS OTHERWISE NOTED, ALL CEILING GRID AND LIGHT FIXTURES SHALL BE CENTERED IN ROOM/OPENING.
- CONTRACTOR TO REVIEW WITH ARCHITECT, ON SITE, AREAS WITH MULTIPLE CEILING, WALL, AND FLOOR FINISHES BEFORE FINISH WORK BEGINS.
- REFER TO RCP LEGEND ON OVERALL REFLECTED CEILING PLANS FOR RCP ABBREVIATIONS AND FINISHES.
- FINISH MATERIALS SHALL BE INSTALLED PER FINISH SCHEDULE AND SPECIFICATIONS; REFER TO FINISH PLAN.
- CONTRACTOR SHALL VERIFY ALL DIMENSIONS AND CONDITIONS ON SITE PRIOR TO CONSTRUCTION.
- NOTIFY ARCHITECT OF ANY DISCREPANCIES OR CONFLICTS BEFORE PROCEEDING.
- COORDINATE ALL PENETRATIONS, CHASES, AND RECESSES WITH MEP DRAWINGS.
- OPCI - OWNER FURNISHED CONTRACTOR INSTALLED
- ALL CMU WALLS ARE TO BE PAINTED PNT-1 UNLESS NOTED OTHERWISE.

## GRANT SCOPE LEGEND

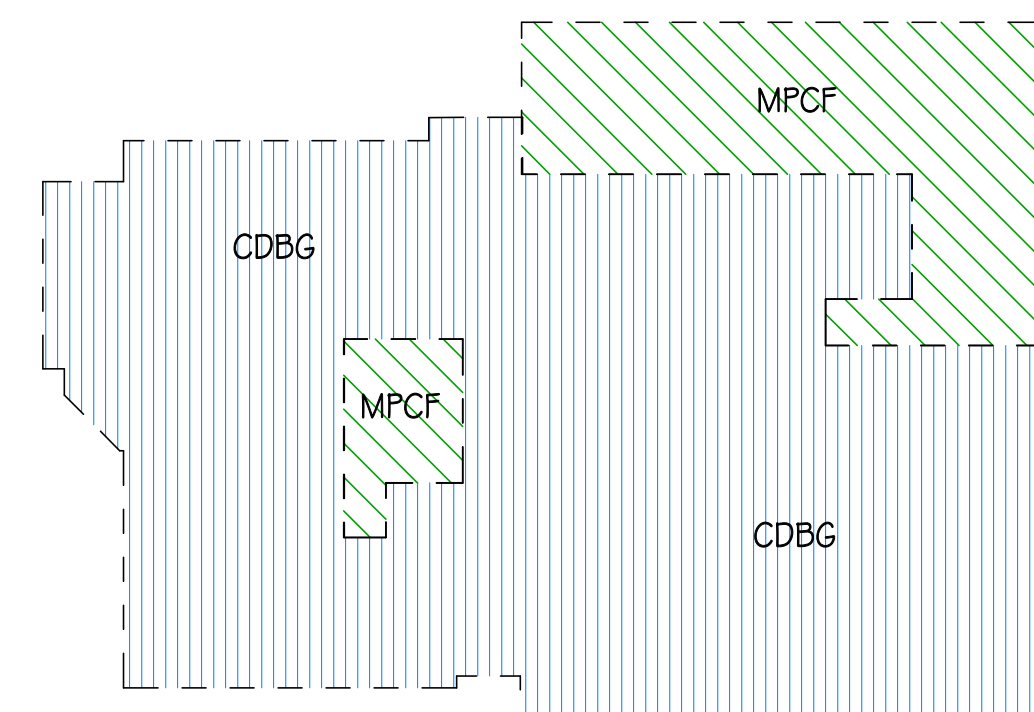

G OODWIN MILLS CAWOOD, LLC.  
720 Bayfront Parkway, Suite 200  
Pensacola, FL 32502  
T 850.432.0706  
GMCNETWORK.COM  
Kelly Wiczonek -  
Qualifying Agent  
FL Architect AR 96359

FRICKER RESOURCE CENTER  
RENOVATION PROJECT

900 N F St, Pensacola, FL 32501-2887

GMC # APEN20016

NEW WORK DIMENSION  
- FLOOR PLAN

A1.03